

NOTES:

- THE LOCATION OF EXISTING UNDERGROUND UTILITIES ARE SHOWN IN AN APPROXIMATE WAY ONLY AND HAVE NOT BEEN INDEPENDENTLY VERIFIED BY THE OWNER OR ITS REPRESENTATIVE. THE CONTRACTOR SHALL DETERMINE THE EXACT LOCATION OF ALL EXISTING UTILITIES BEFORE COMMENCING WORK, AND AGREES TO BE FULLY RESPONSIBLE FOR ANY AND ALL DAMAGES WHICH MIGHT BE OCCASIONED BY THE CONTRACTOR'S FAILURE TO EXACTLY LOCATE AND PRESERVE ANY AND ALL UNDERGROUND UTILITIES. CONTACT U.B.C. UTILITIES 72 HOURS PRIOR TO START OF CONSTRUCTION 604-822-9570.
- ALL CONSTRUCTION TO MMCD (2000) AND U.B.C. TECHNICAL GUIDELINES

NO	DATE	REVISIONS
1	29 JAN/10	INFORMATION ONLY



SEAL



BUILDING / FACULTY

EAST CAMPUS

PROJECT TITLE


LOT 1

DRAWING TITLE

STREET LIGHTS PLAN

SCALE H: 1:250	DATE : JAN. 2010
DRAWN T.W.	SHEET No.
REVISED C.W.D.	
10-023- STL	
UBC PROJECT No.	
UBC DRAWING No.	08

Jan 28 2010 11:50am M:\2010\10-023\DWG\10-023-Master.dwg/08-STL.twg

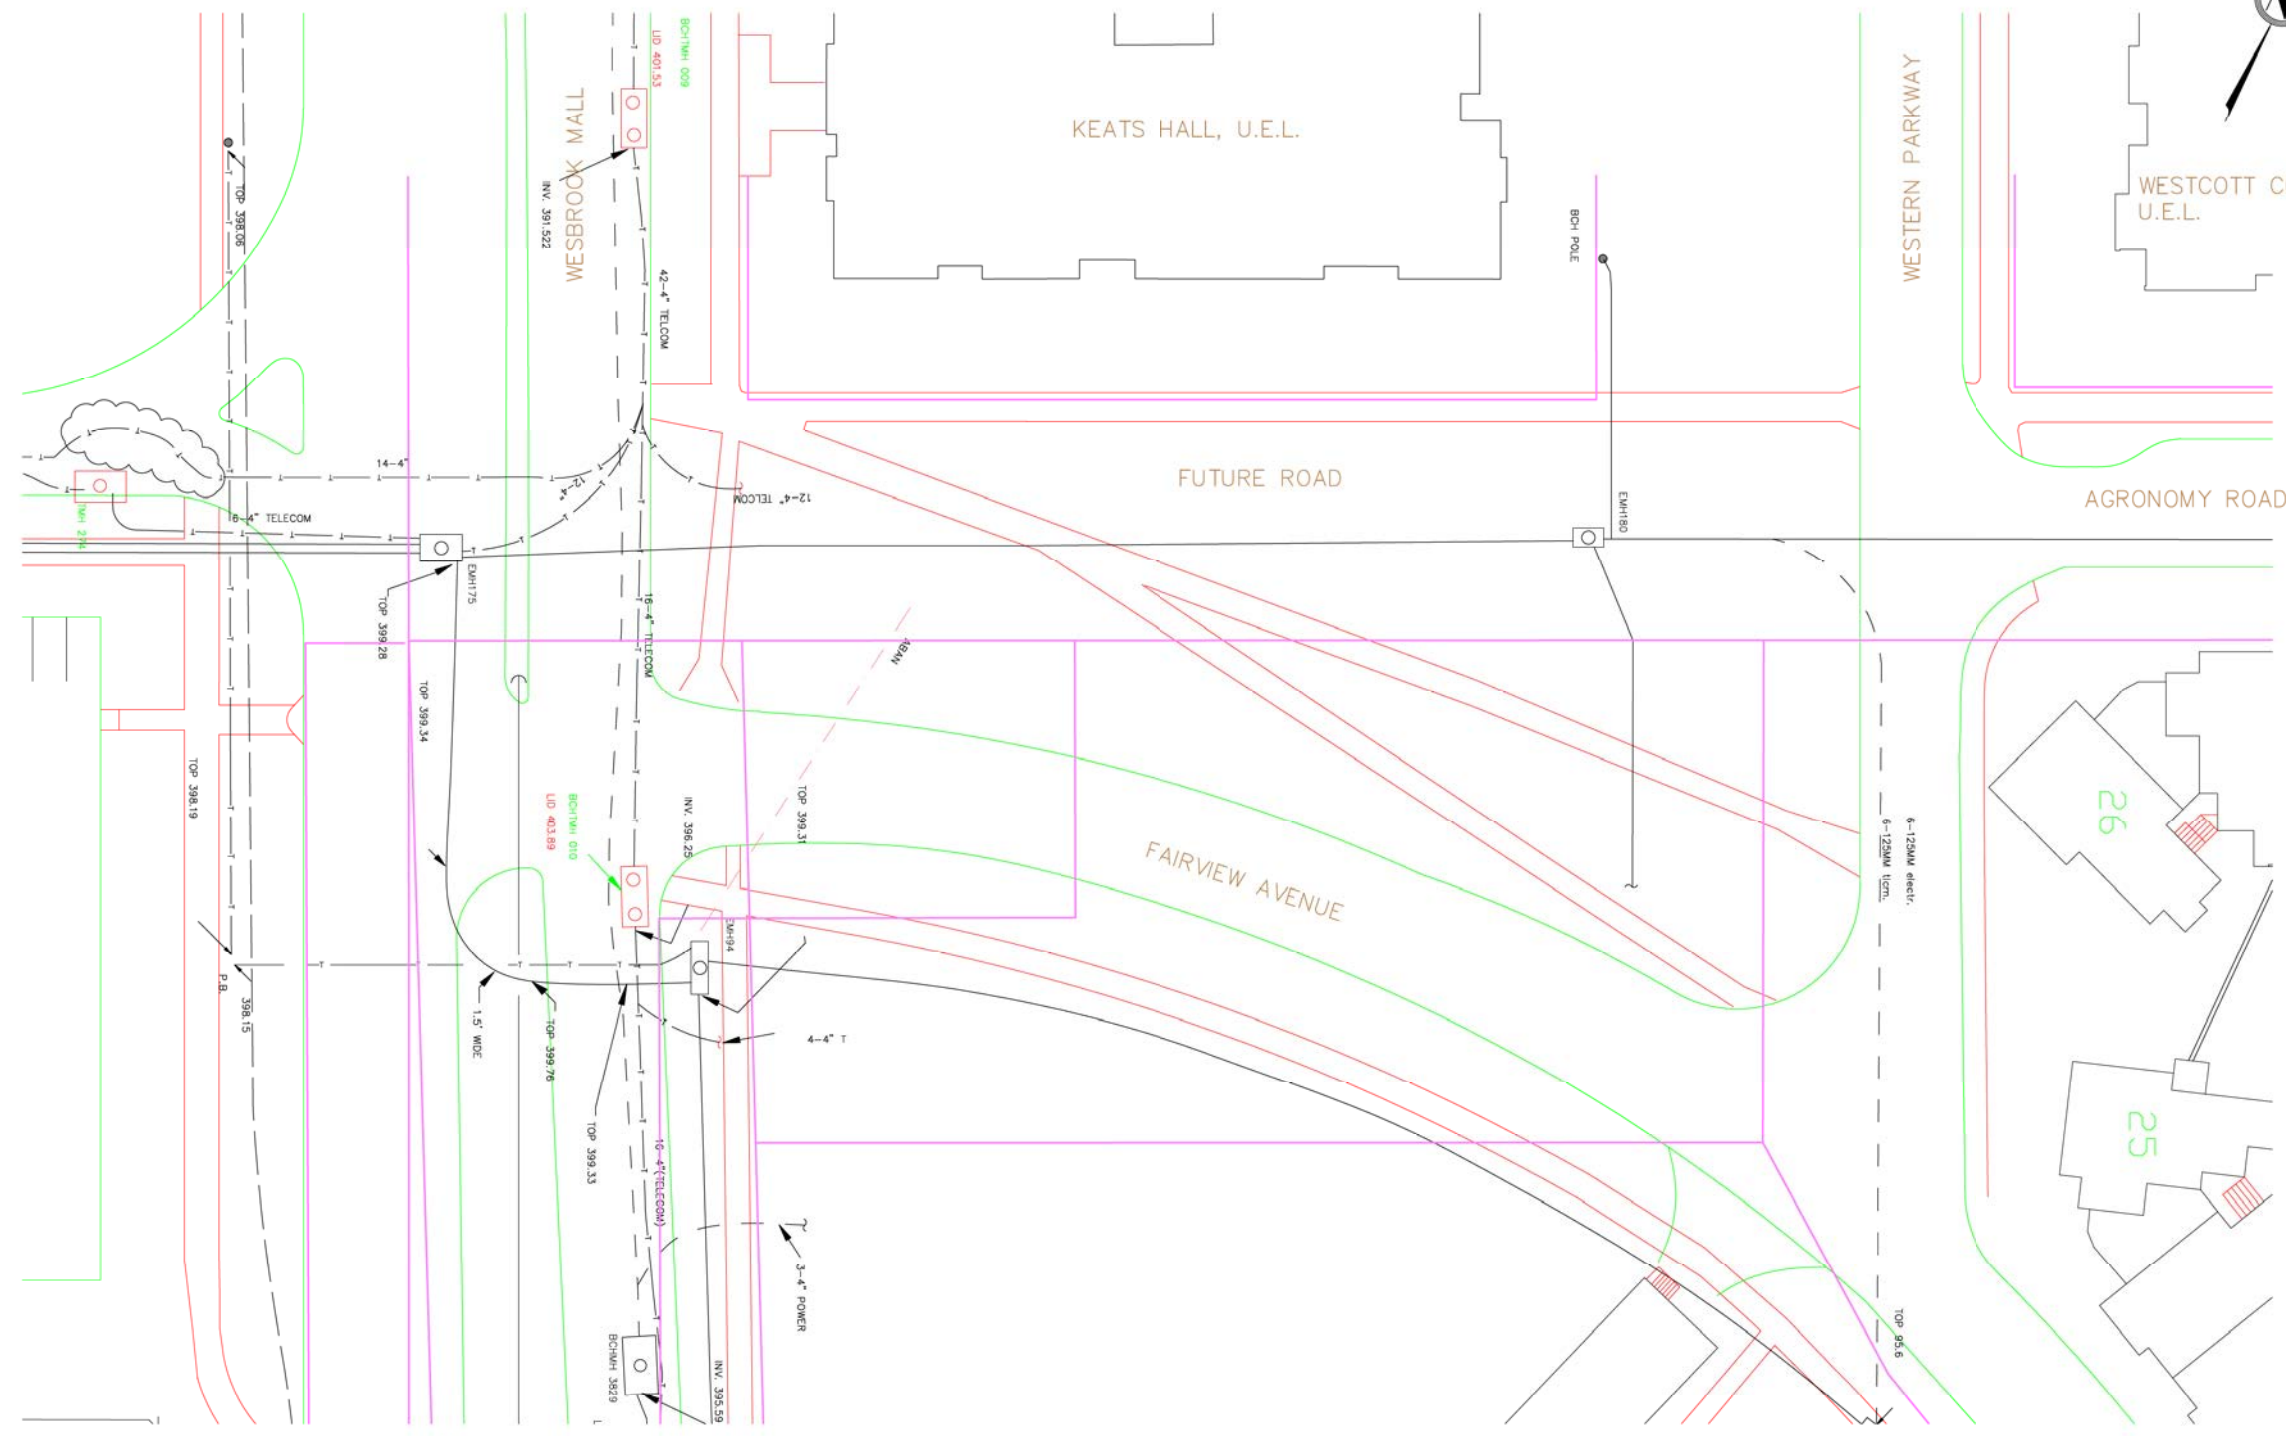

NOTES:

- THE LOCATION OF EXISTING UNDERGROUND UTILITIES ARE SHOWN IN AN APPROXIMATE WAY ONLY AND HAVE NOT BEEN INDEPENDENTLY VERIFIED BY THE OWNER OR ITS REPRESENTATIVE. THE CONTRACTOR SHALL DETERMINE THE EXACT LOCATION OF ALL EXISTING UTILITIES BEFORE COMMENCING WORK, AND AGREES TO BE FULLY RESPONSIBLE FOR ANY AND ALL DAMAGES WHICH MIGHT BE OCCASIONED BY THE CONTRACTOR'S FAILURE TO EXACTLY LOCATE AND PRESERVE ANY AND ALL UNDERGROUND UTILITIES. CONTACT U.B.C. UTILITIES 72 HOURS PRIOR TO START OF CONSTRUCTION 604-822-9570.
- ALL CONSTRUCTION TO MMCD (2000) AND U.B.C. TECHNICAL GUIDELINES

NO	DATE	REVISIONS
1	29 JAN/10	INFORMATION ONLY



SEAL



The University of British Columbia

BUILDING / FACILITY
EAST CAMPUS

PROJECT TITLE
LOT 1

DRAWING TITLE
ELECTRICAL & TELECOM PLAN

SCALE H: 1:250 DATE : JAN. 2010

DRAWN T.W. SHEET No.


REVISED C.W.D.

10-023-ELEC/TEL

UBC PROJECT No.

UBC DRAWING No. **07**

Jan 28 2010 11:50am M:\2010\10-023\023-023-Master.dwg/07-ELEC&TELCOM 1:250

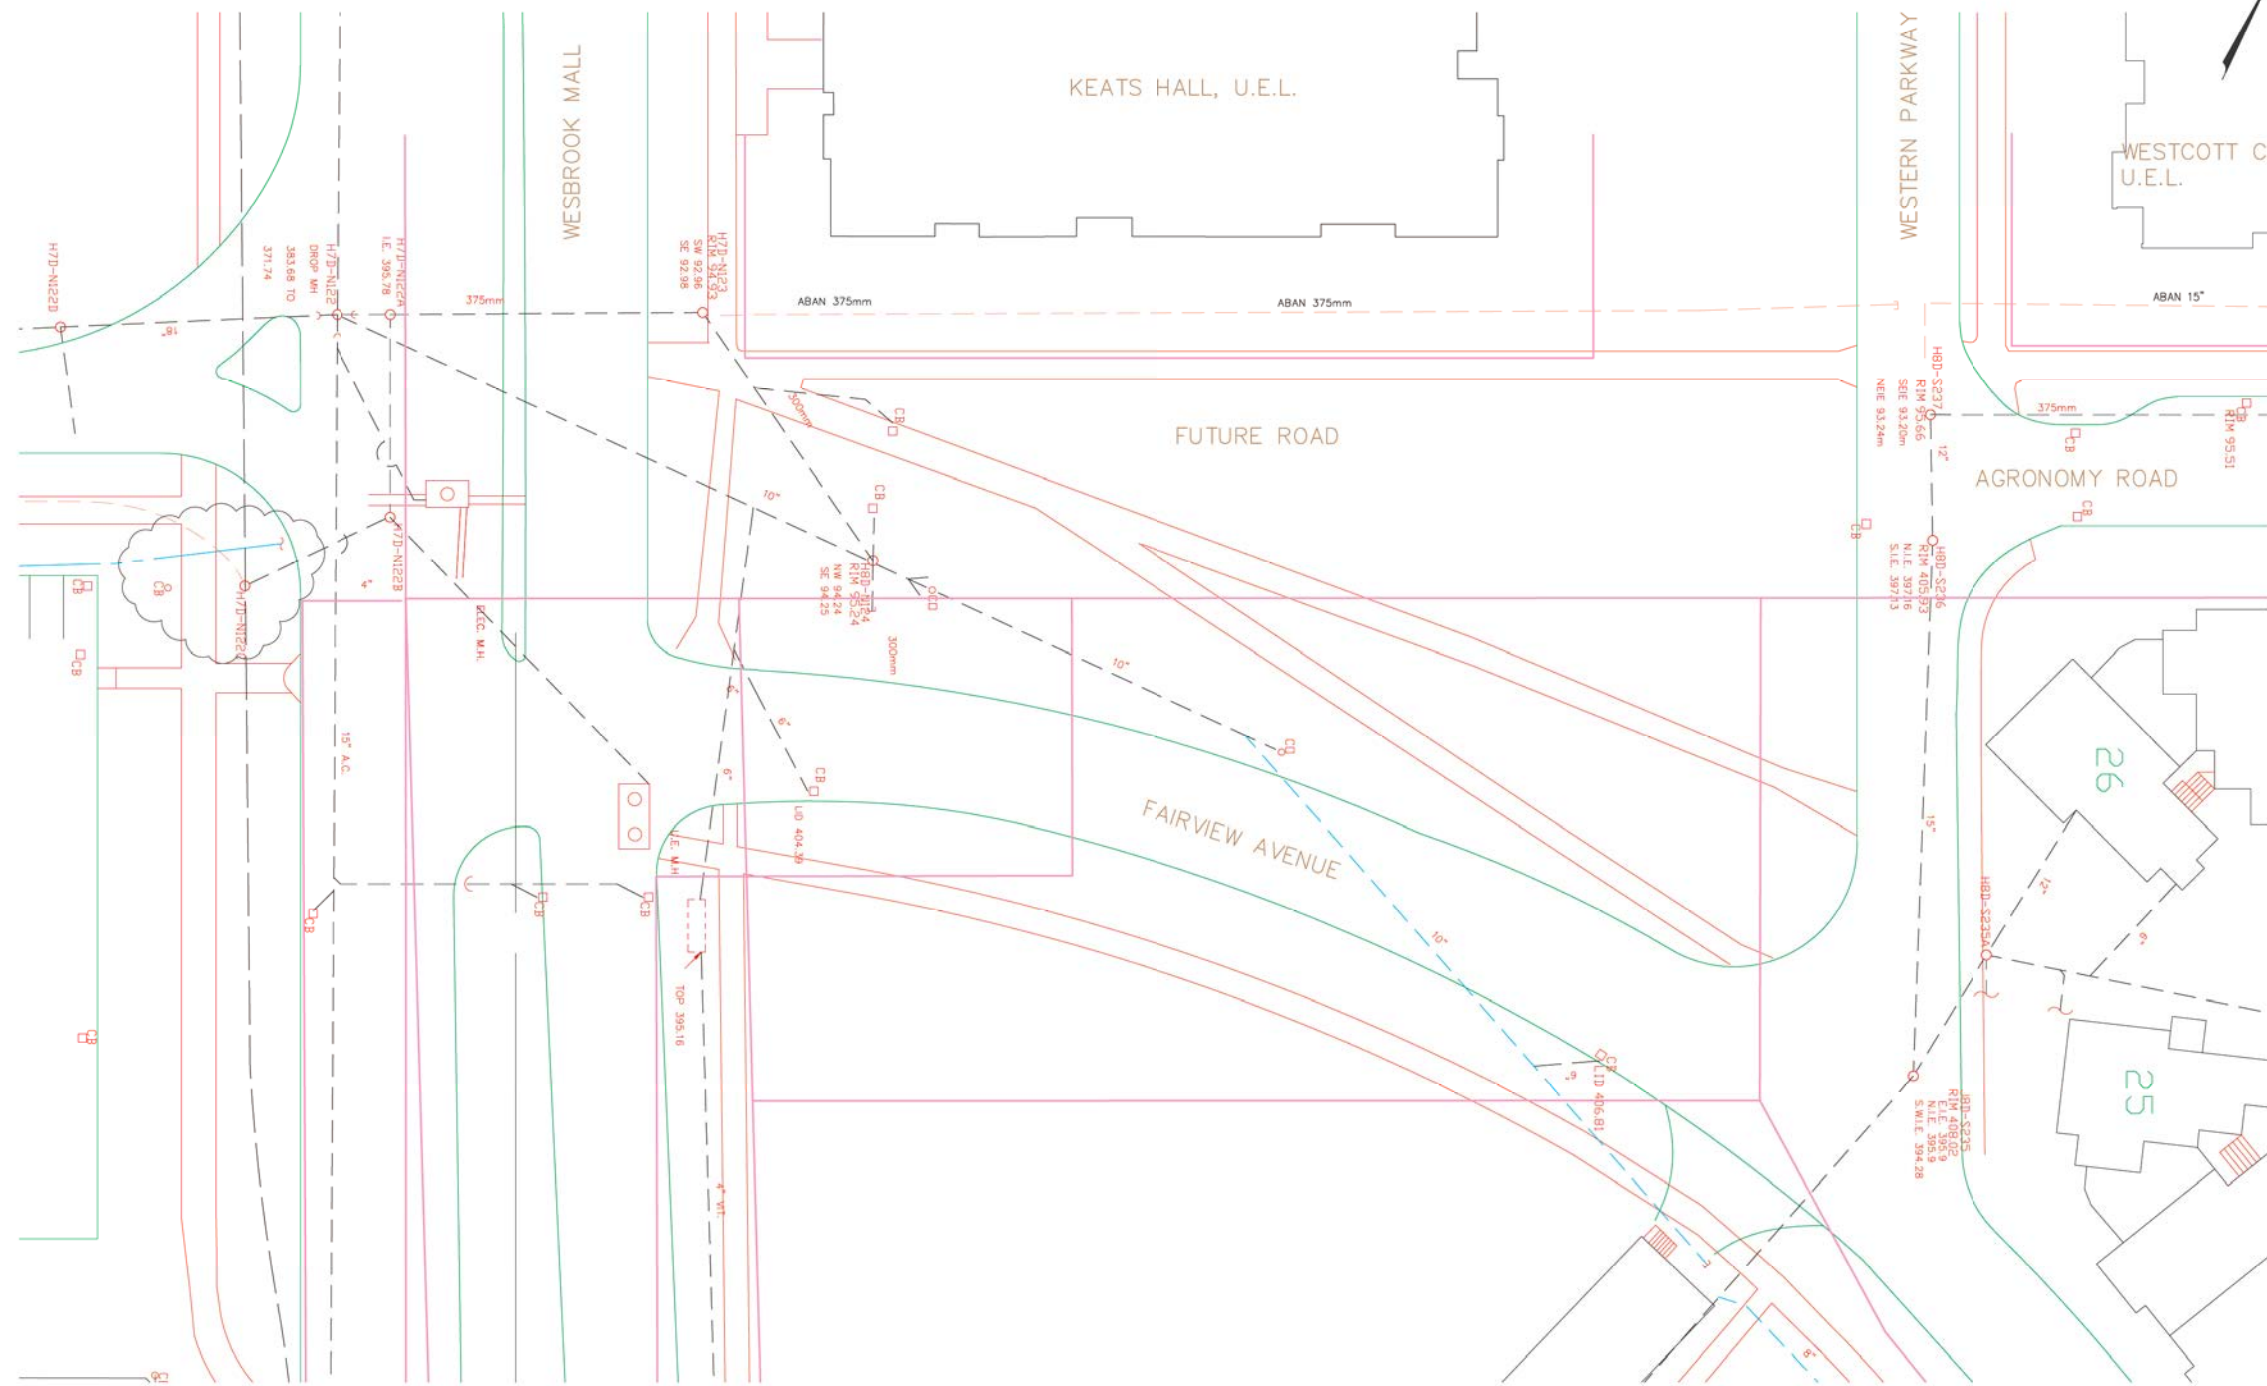

NOTES:

- THE LOCATION OF EXISTING UNDERGROUND UTILITIES ARE SHOWN IN AN APPROXIMATE WAY ONLY AND HAVE NOT BEEN INDEPENDENTLY VERIFIED BY THE OWNER OR ITS REPRESENTATIVE. THE CONTRACTOR SHALL DETERMINE THE EXACT LOCATION OF ALL EXISTING UTILITIES BEFORE COMMENCING WORK, AND AGREES TO BE FULLY RESPONSIBLE FOR ANY AND ALL DAMAGES WHICH MIGHT BE OCCASIONED BY THE CONTRACTOR'S FAILURE TO EXACTLY LOCATE AND PRESERVE ANY AND ALL UNDERGROUND UTILITIES. CONTACT U.B.C. UTILITIES 72 HOURS PRIOR TO START OF CONSTRUCTION 604-822-9570.
- ALL CONSTRUCTION TO MMCD (2000) AND U.B.C. TECHNICAL GUIDELINES

NO	DATE	REVISIONS
1	29 JAN/10	INFORMATION ONLY



SEAL




BUILDING / FACULTY
EAST CAMPUS

PROJECT TITLE
LOT 1

DRAWING TITLE
STORM SEWER PLAN

SCALE H: 1:250	DATE : JAN. 2010
DRAWN T.W.	SHEET No.
REVISED C.W.D.	
10-023- D	
UBC PROJECT No.	
UBC DRAWING No.	06

Jan 28 2010 - 11:50am M:\2010\10-023\DWG\10-023-Master.dwg/06-01W.txd

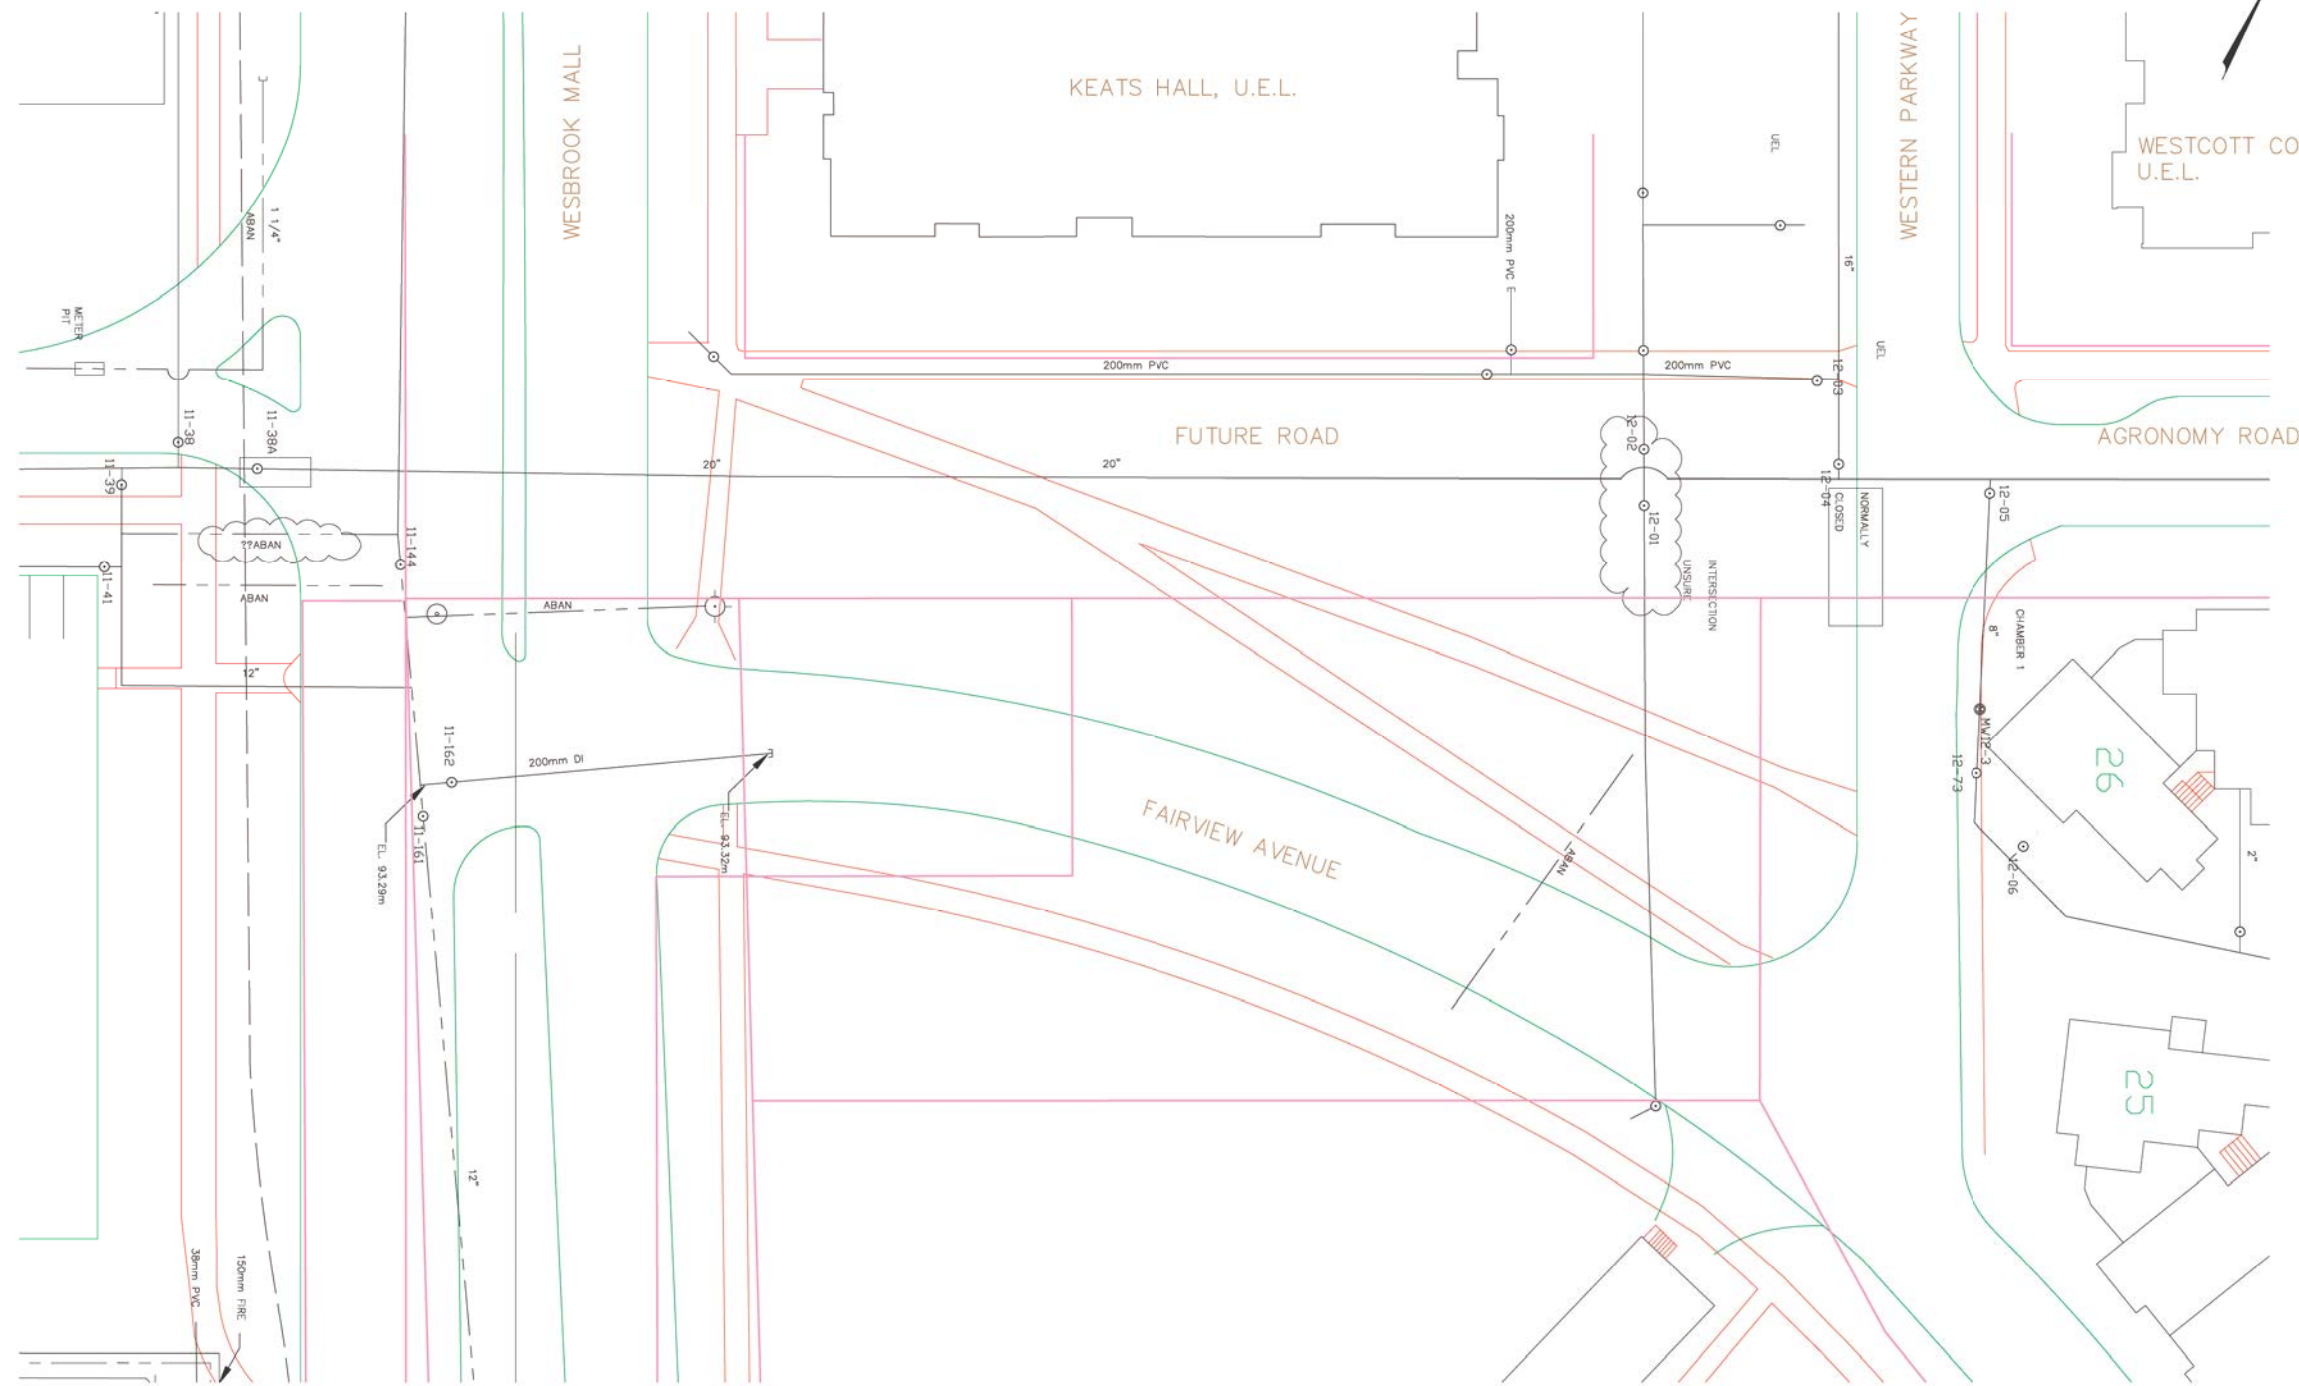

NOTES:

— THE LOCATION OF EXISTING UNDERGROUND UTILITIES ARE SHOWN IN AN APPROXIMATE WAY ONLY AND HAVE NOT BEEN INDEPENDENTLY VERIFIED BY THE OWNER OR ITS REPRESENTATIVE. THE CONTRACTOR SHALL DETERMINE THE EXACT LOCATION OF ALL EXISTING UTILITIES BEFORE COMMENCING WORK, AND AGREES TO BE FULLY RESPONSIBLE FOR ANY AND ALL DAMAGES WHICH MIGHT BE OCCASIONED BY THE CONTRACTOR'S FAILURE TO EXACTLY LOCATE AND PRESERVE ANY AND ALL UNDERGROUND UTILITIES. CONTACT U.B.C. UTILITIES 72 HOURS PRIOR TO START OF CONSTRUCTION 604-822-9570.

— ALL CONSTRUCTION TO MMCD (2000) AND U.B.C. TECHNICAL GUIDELINES

NO	DATE	REVISIONS
1	29 JAN/10	INFORMATION ONLY

1 29 JAN/10 INFORMATION ONLY



SEAL

UBC PROPERTIES TRUST



The University of British Columbia



BUILDING / FACULTY

EAST CAMPUS

PROJECT TITLE

LOT 1

DRAWING TITLE

WATERMAIN PLAN

SCALE H: 1:250 DATE: JAN. 2010

DRAWN T.W. SHEET No.


REVISED C.W.D.

10-023- W

UBC PROJECT No.

UBC DRAWING No.

04

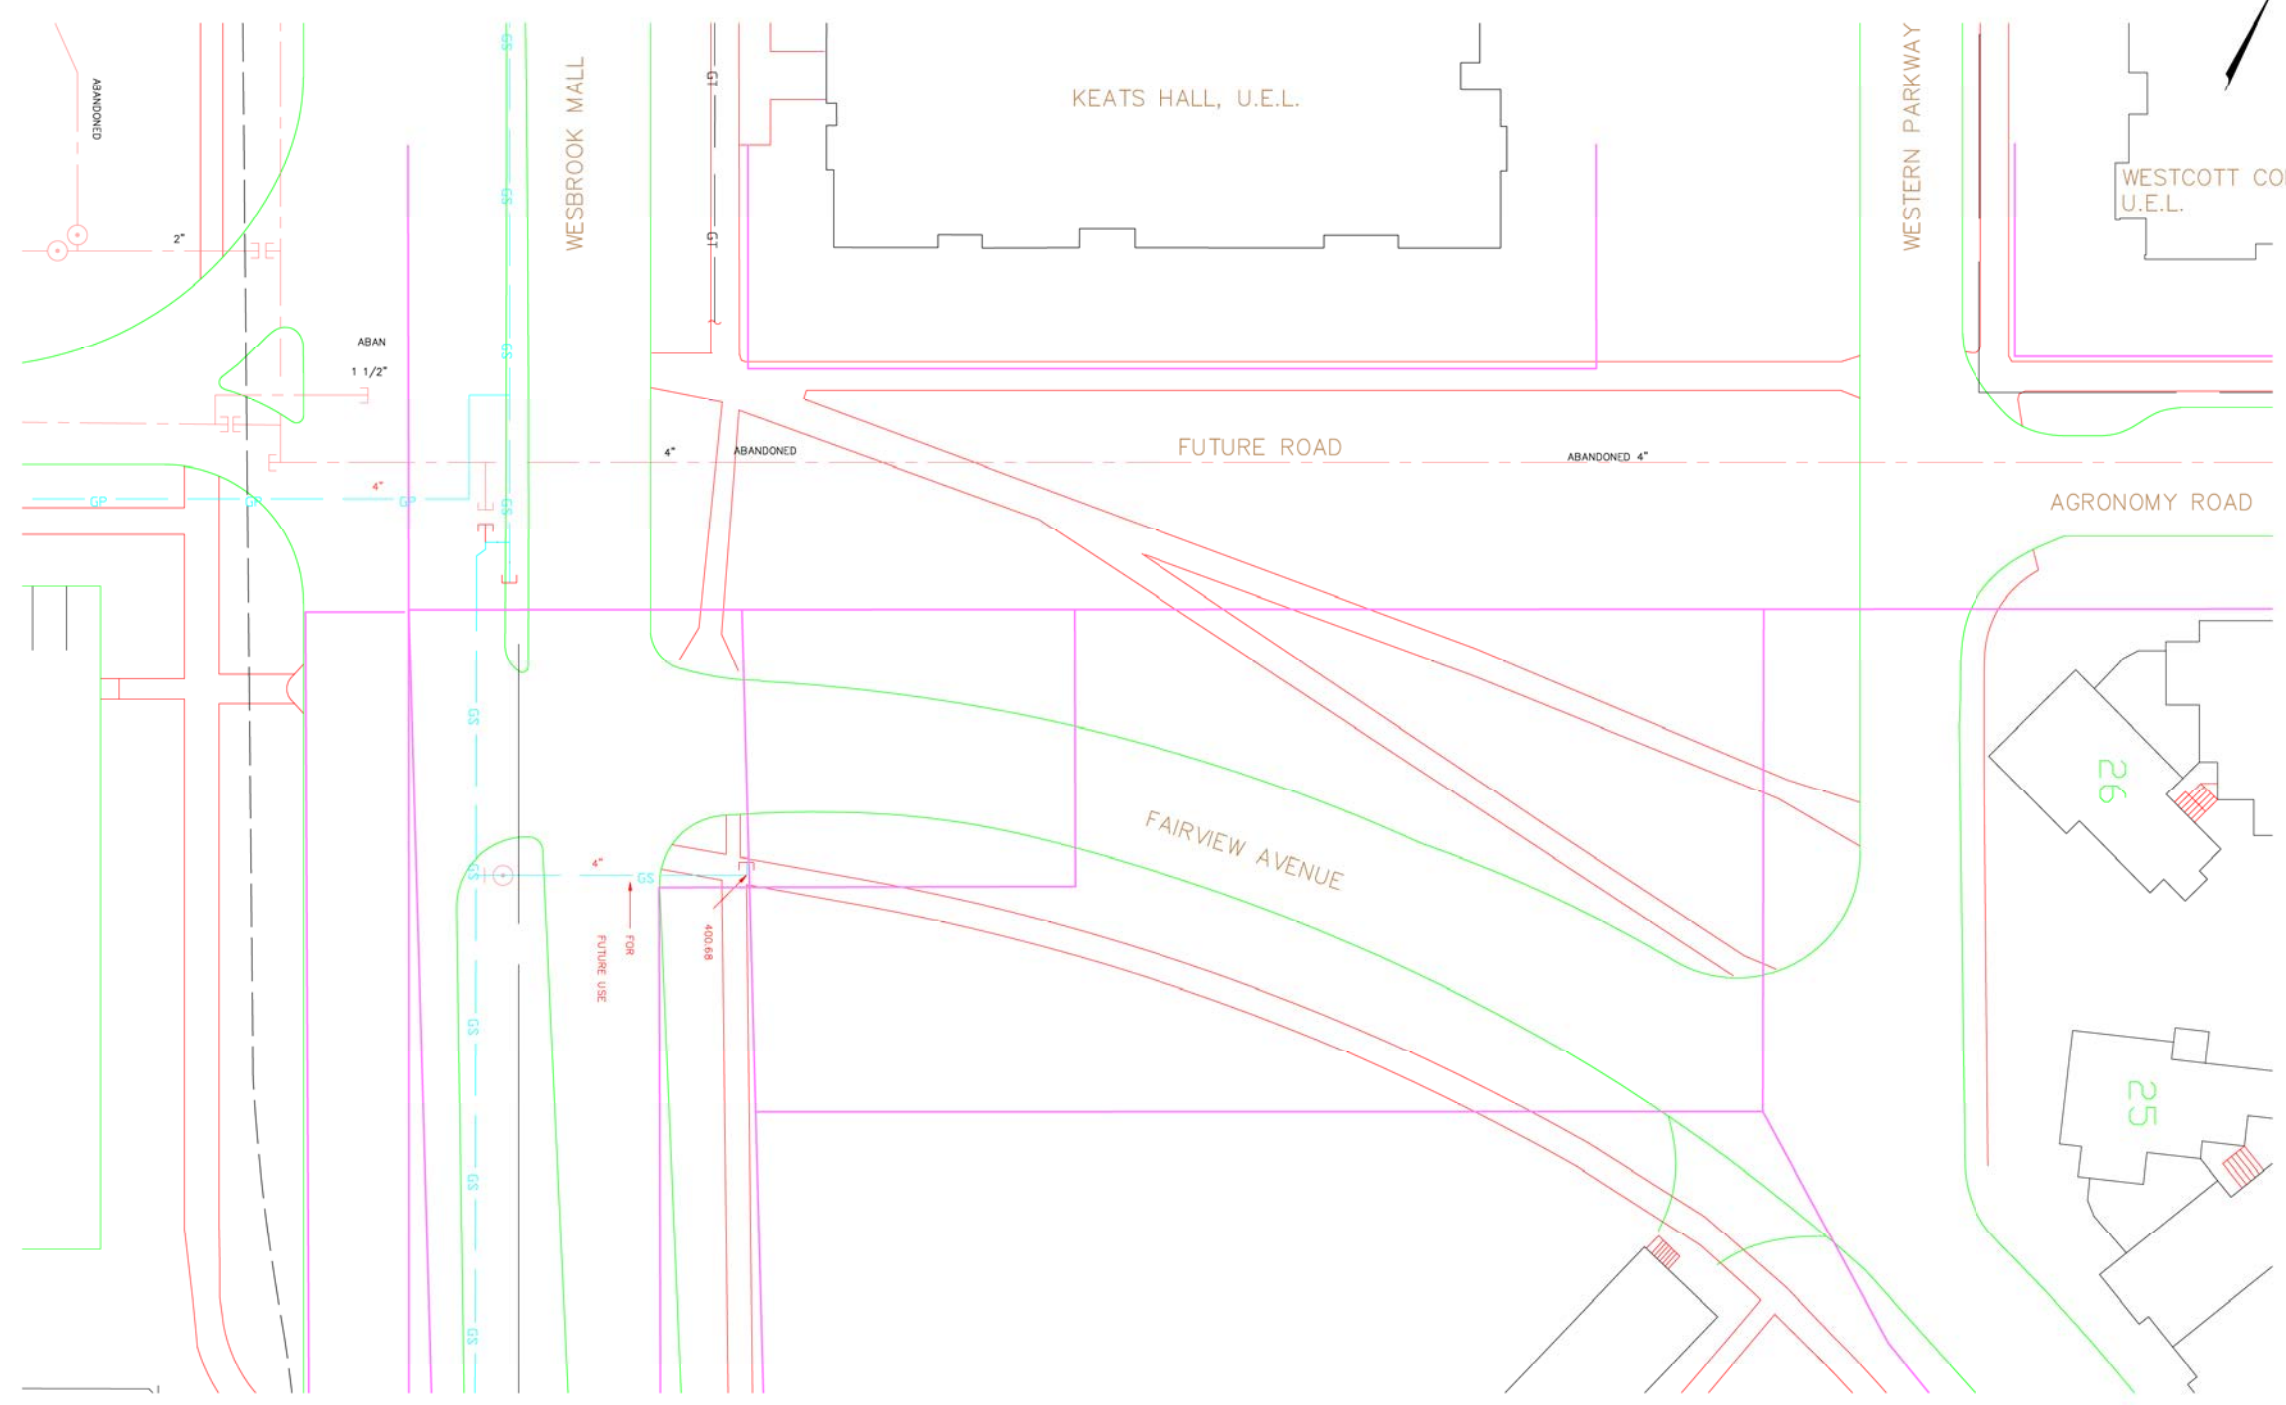

NOTES:

— THE LOCATION OF EXISTING UNDERGROUND UTILITIES ARE SHOWN IN AN APPROXIMATE WAY ONLY AND HAVE NOT BEEN INDEPENDENTLY VERIFIED BY THE OWNER OR ITS REPRESENTATIVE. THE CONTRACTOR SHALL DETERMINE THE EXACT LOCATION OF ALL EXISTING UTILITIES BEFORE COMMENCING WORK, AND AGREES TO BE FULLY RESPONSIBLE FOR ANY AND ALL DAMAGES WHICH MIGHT BE OCCASIONED BY THE CONTRACTOR'S FAILURE TO EXACTLY LOCATE AND PRESERVE ANY AND ALL UNDERGROUND UTILITIES. CONTACT U.B.C. UTILITIES 72 HOURS PRIOR TO START OF CONSTRUCTION 604-822-9570.

— ALL CONSTRUCTION TO MMCD (2000) AND U.B.C. TECHNICAL GUIDELINES

NO	DATE	REVISIONS
1	29 JAN/10	INFORMATION ONLY

APLIN & MARTIN
CONSULTANTS LTD

80 - 1248 82 Avenue, Surrey, B.C. Canada V3W 5E9
Tel: 604 273 2900 Fax: 604 273 2901 E-mail: aml@aplinc.com

SEAL

UBC PROPERTIES TRUST



The University of British Columbia



BUILDING / FACULTY

EAST CAMPUS

PROJECT TITLE

LOT 1

DRAWING TITLE

GAS LINE PLAN

SCALE H: 1:250	DATE : JAN. 2010
DRAWN T.W.	SHEET No.
REVISED C.W.D.	
10-023- G	
UBC PROJECT No.	
UBC DRAWING No.	09

Jan 28 2010 11:50am M:\2010\10-023\023\023\023-Master.dwg/09-GAS Line.g