


- LEGEND:**
- NOTES:
  - RC RECYCLING CART
  - RD ROOF DRAIN
  - OFS OVERFLOW SCUPPER
  - RWL RAIN WATER LEADER
  - FD FLOOR DRAIN

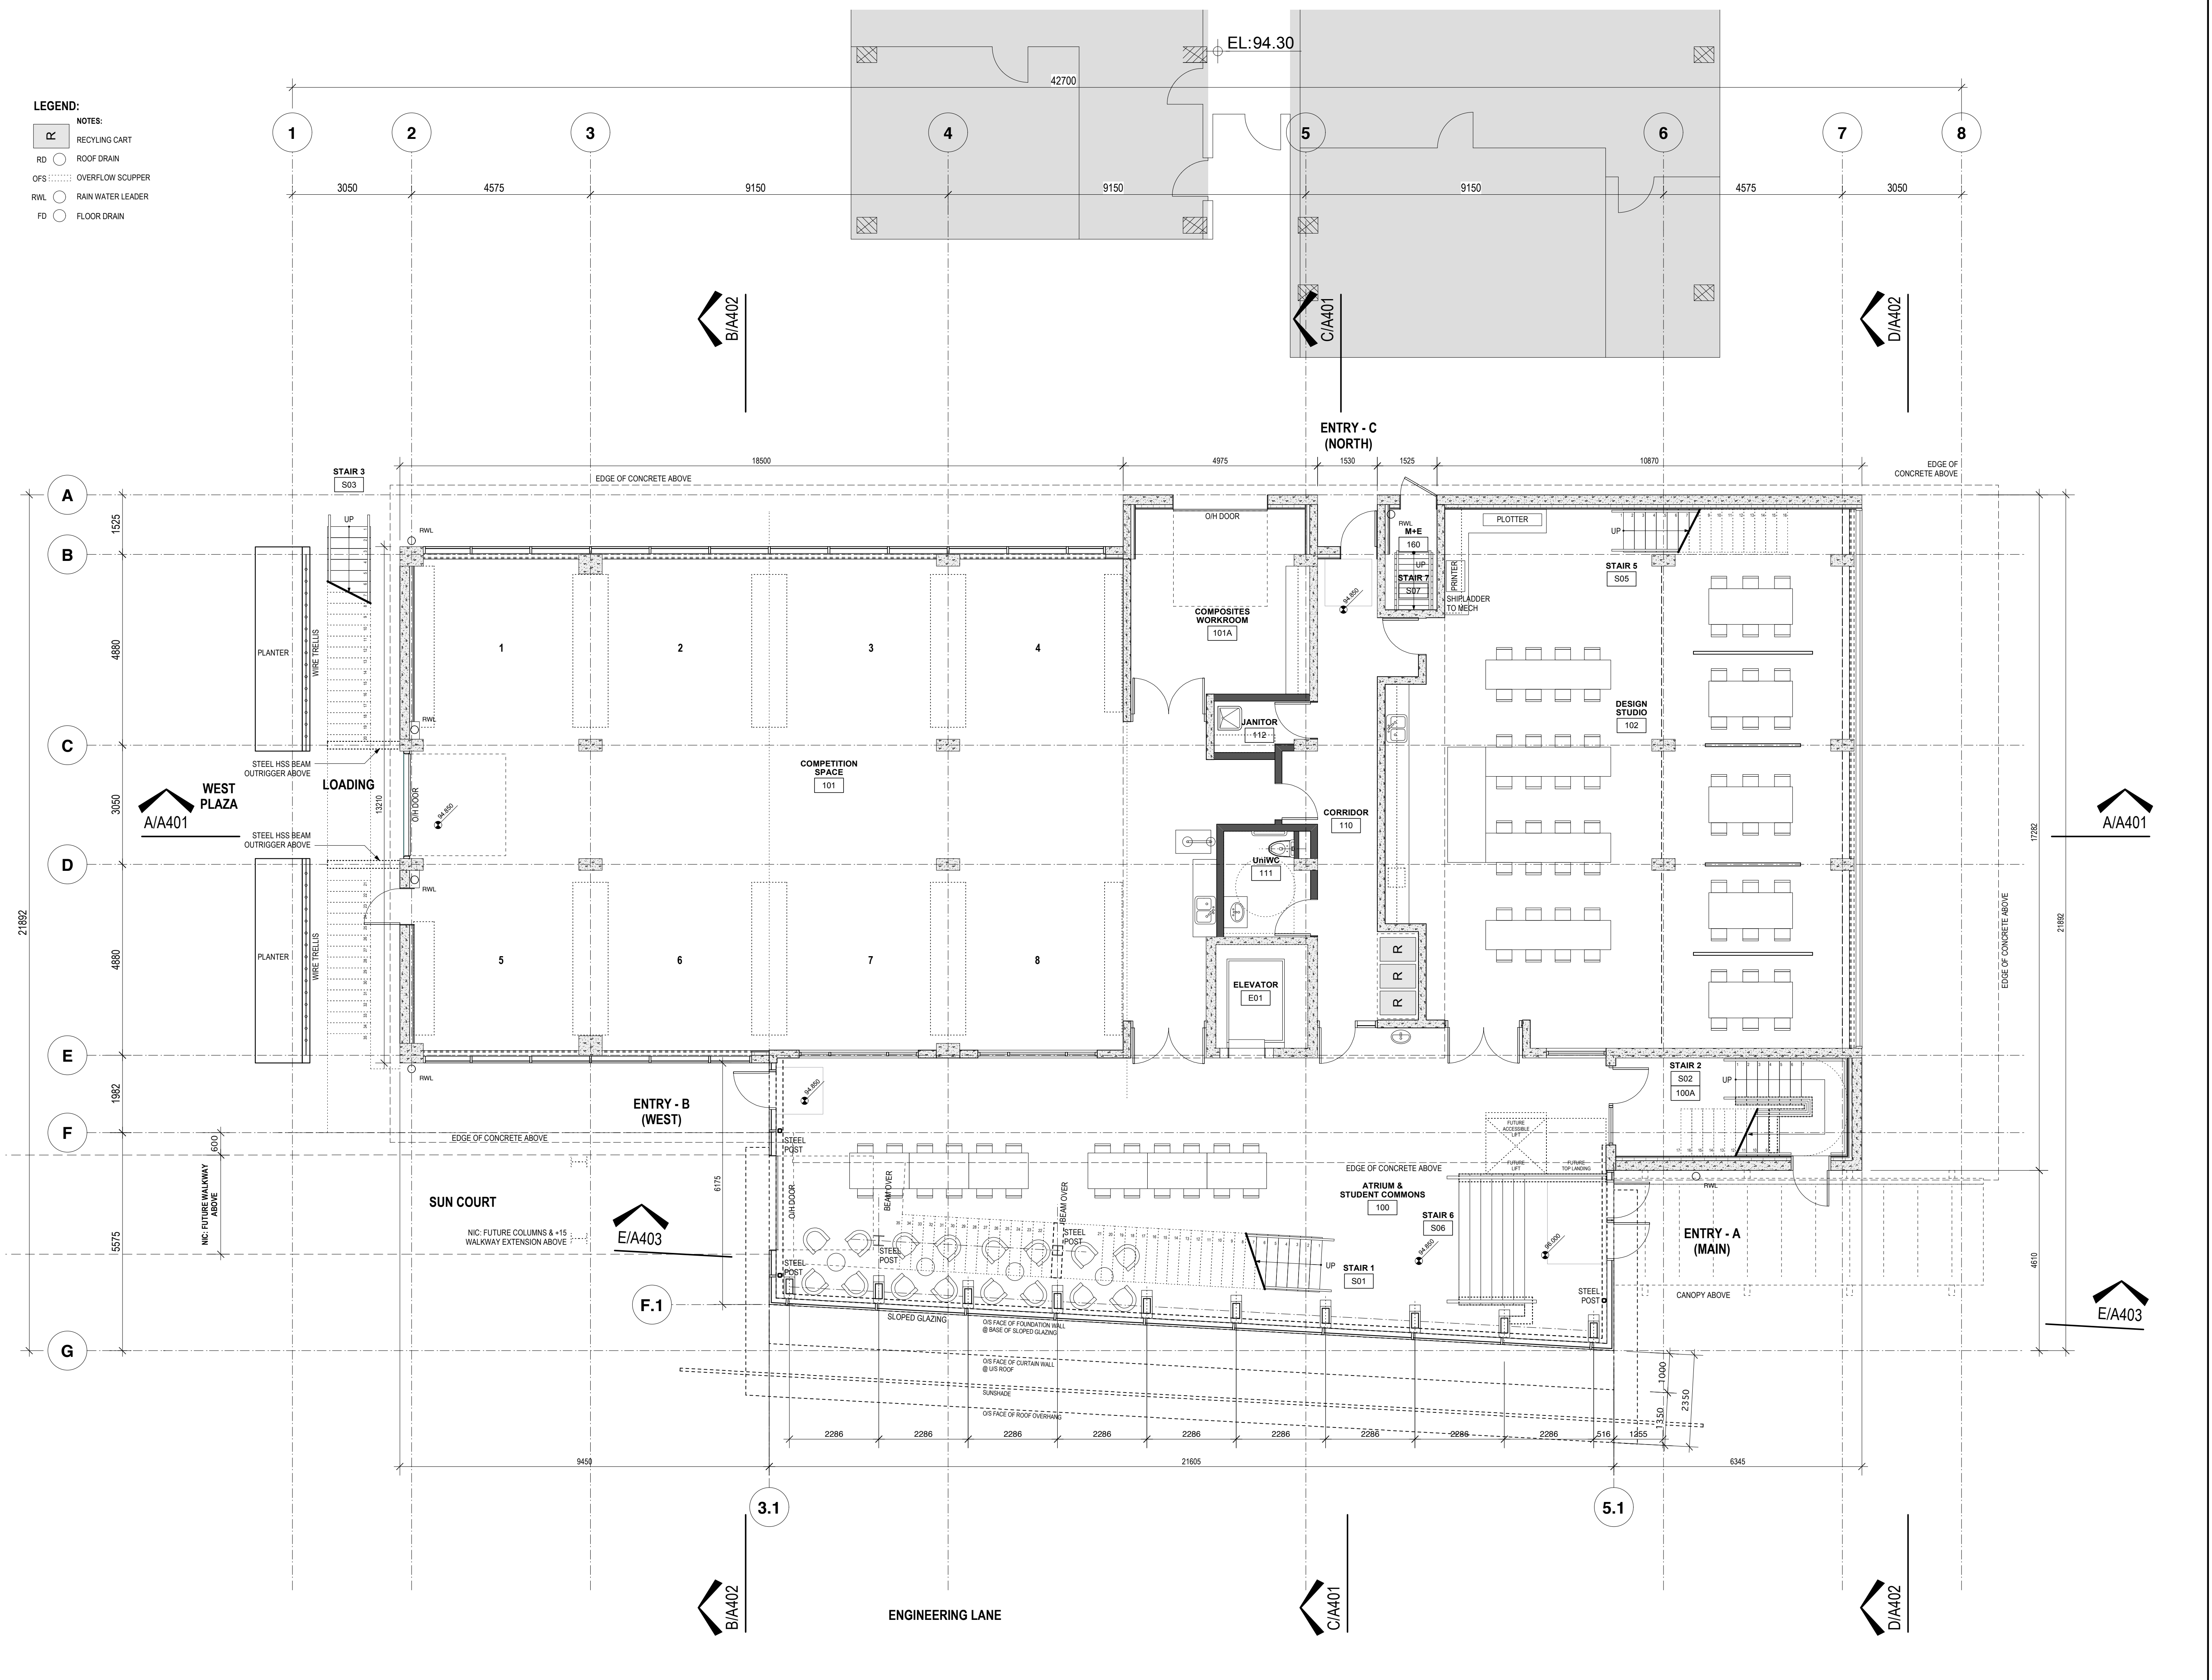


ISSUE / REVISION:		
No.	Date	Description
-	2008.07.29	SUBMISSION FOR ADVISORY DESIGN PANEL
-	2008.07.29	ISSUED FOR DP APPLICATION
-	2008.08.08	ISSUED FOR COSTING AND COORDINATION
-	2009.06.25	ISSUED FOR COSTING AND COORDINATION
-	2009.08.14	DESIGN DEVELOPMENT SIGN OFF
-	2010.02.02	AUDP UPDATE
-	2010.03.26	DEVELOPMENT PERMIT

**CONSULTANTS:**

McFarland Marceau Architects Ltd. (including its employees and agents) can take no responsibility for the accuracy or use of any information on this drawing pertaining to existing site conditions, including buildings, services and utilities. It is the responsibility of the person using said information to verify its accuracy. Should any discrepancy with the actual site conditions be found, it must be reported to the Architect, with time being of the essence.

This drawing, as an instrument of service, is the property of McFarland Marceau Architects Ltd. and may not be reproduced without their permission and unless the reproduction carries their name. All designs and other information shown on this drawing are for use on the specified project only and shall not be used otherwise without written permission of this office.

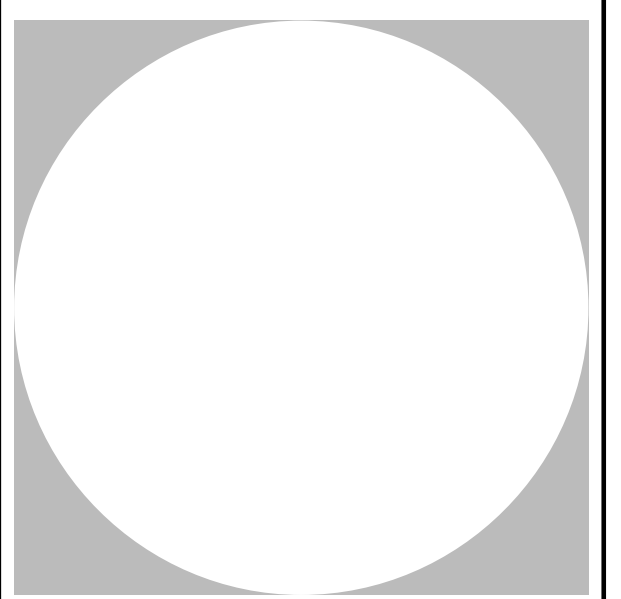

**McFARLAND MARCEAU ARCHITECTS LTD**

programming | planning | architecture

303 - 2930 Arbutus Street  
 Vancouver, BC, V6J 3Y9  
 t. 604 733 1115  
 f. 604 733 9345  
 www.mmal.ca

LMAL Project No.: 0803  
 File name: 0803 CD Plans + Site Plans

**PROJECT TITLE:**  
**WAYNE and WILLIAM WHITE**

**ENGINEERING DESIGN CENTRE UBC**


**PROJECT PHASE:**  
**Dev Permit Documents**

**DRAWING TITLE:**  
**MAIN FLOOR PLAN**

Date Plotted:  
 Scale: 1:75  
 Drawn: FJ  
 Checked:

**DRAWING NUMBER:**  
**A111**

- LEGEND:**
- NOTES:
  - RC RECYLING CART
  - RD ROOF DRAIN
  - OFS OVERFLOW SCUPPER
  - RWL RAIN WATER LEADER
  - FD FLOOR DRAIN

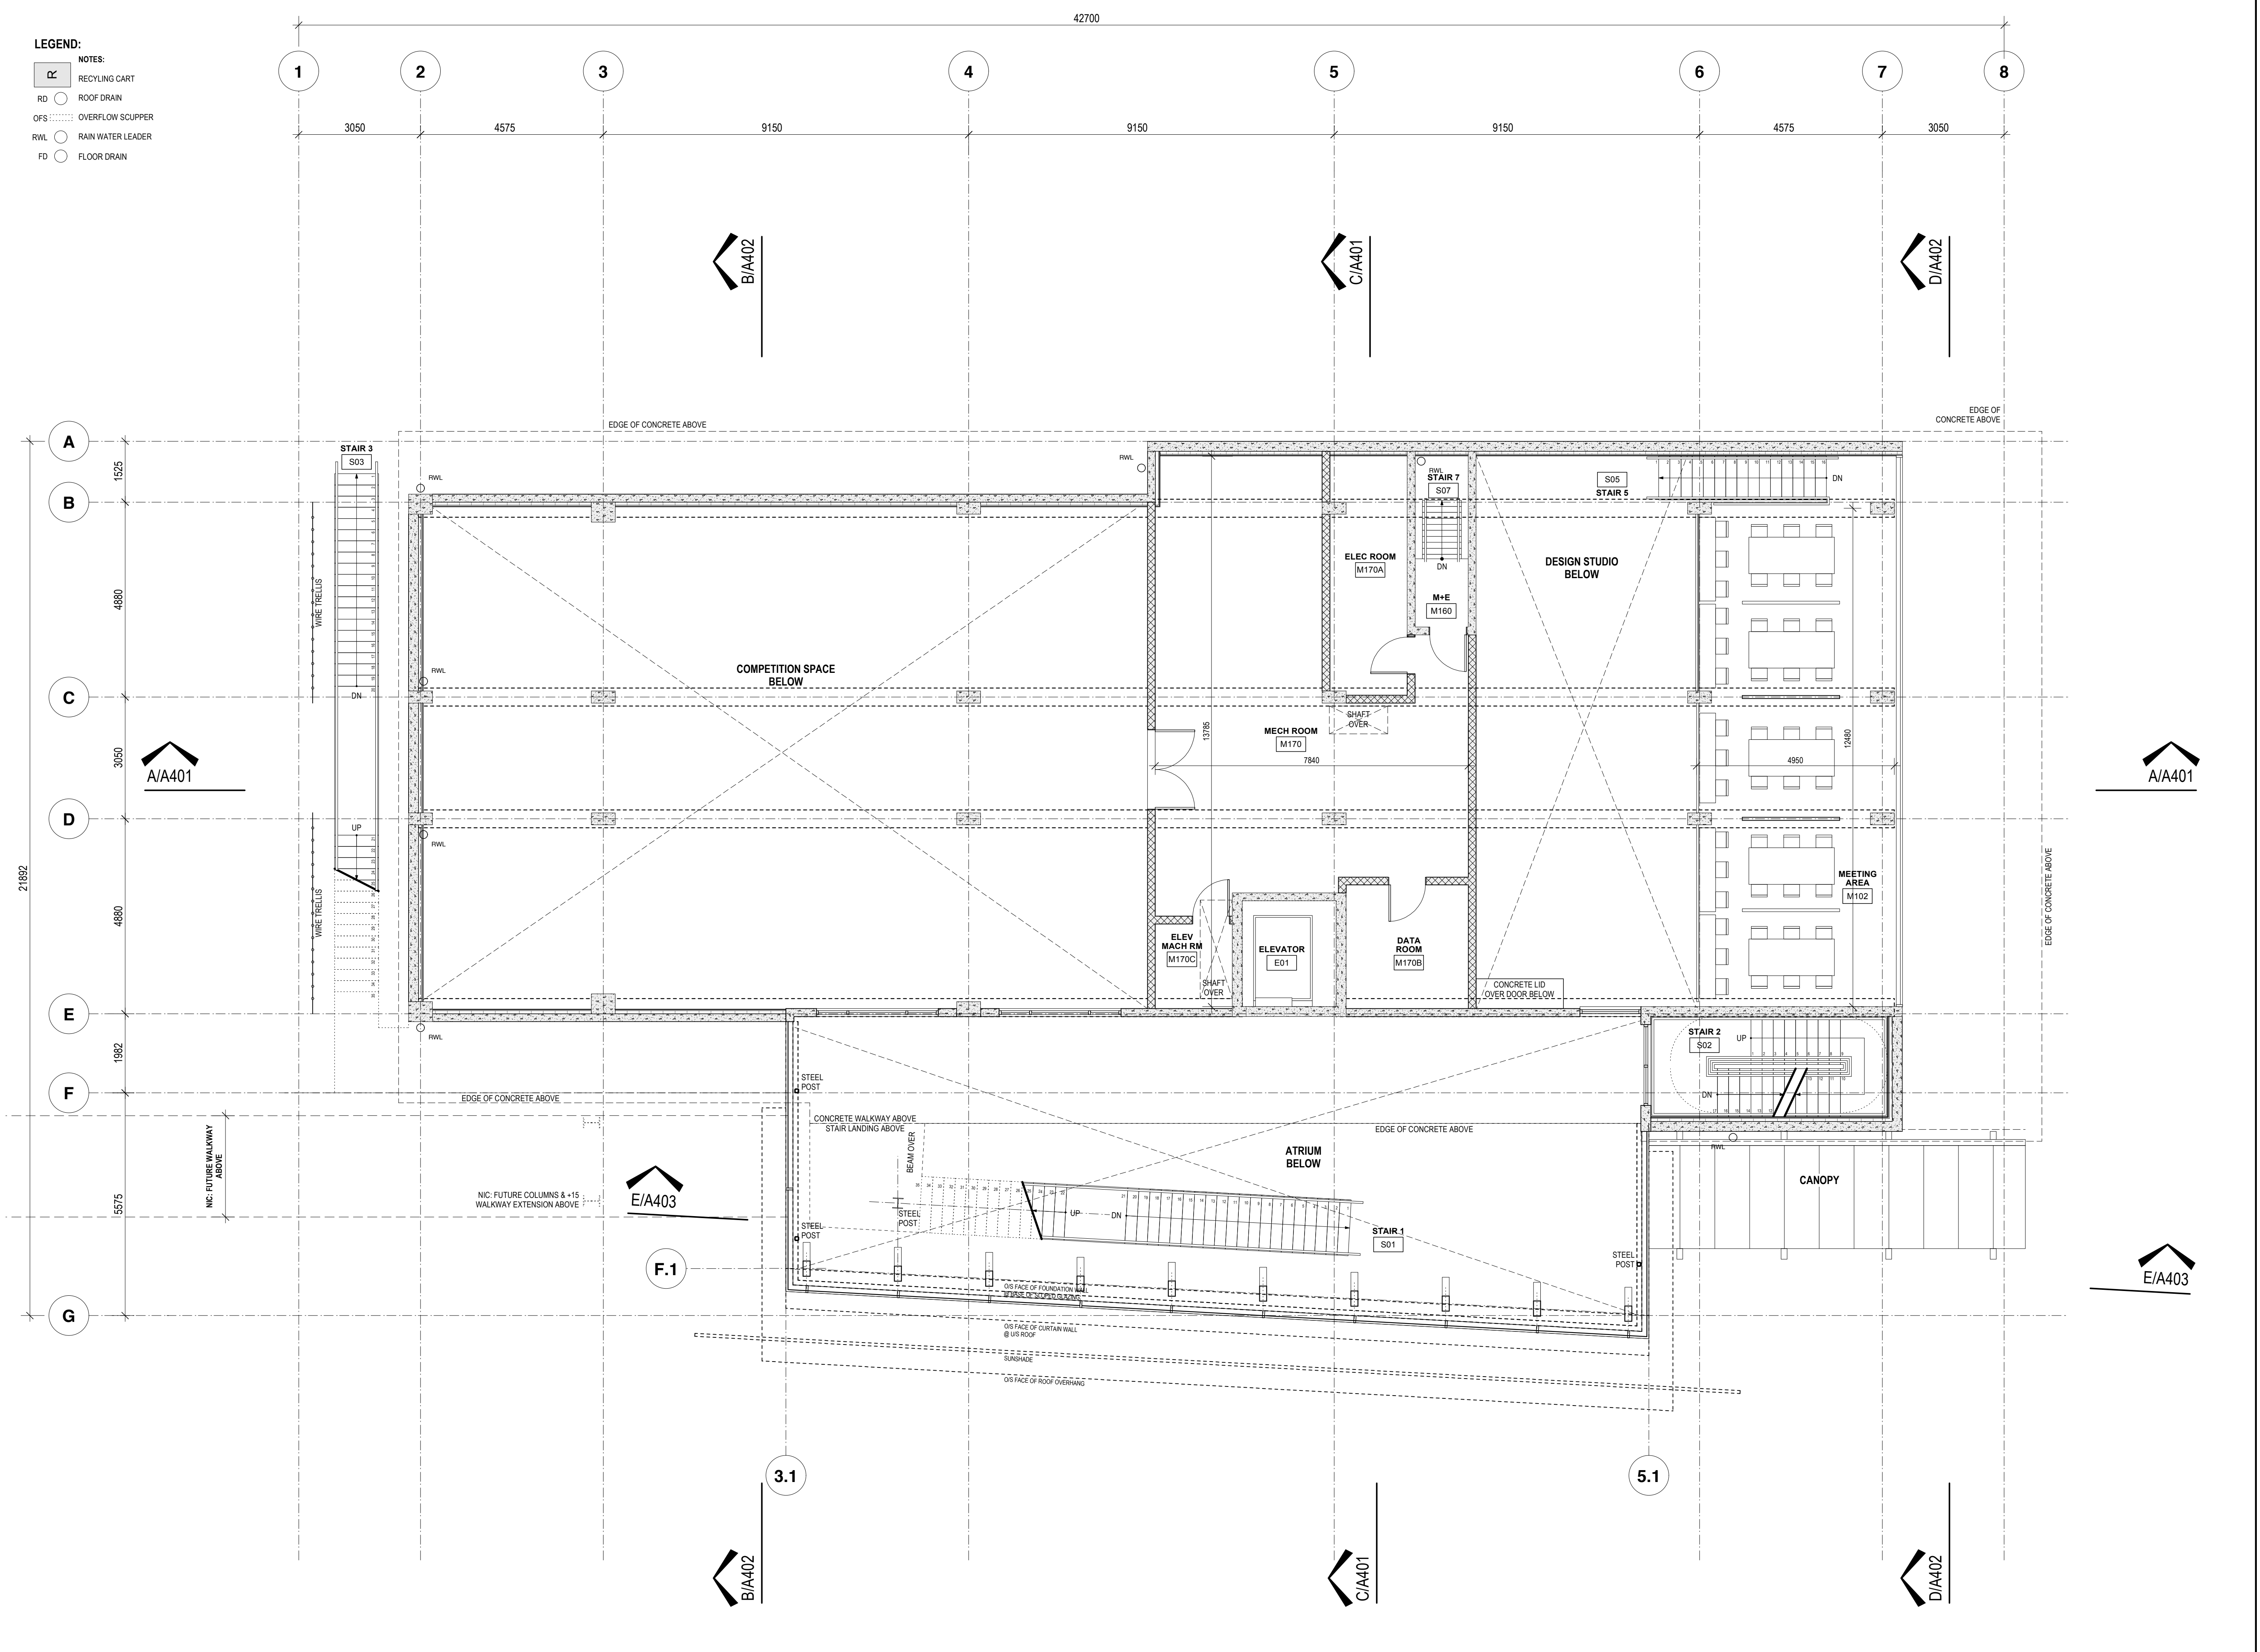


ISSUE / REVISION:		
No.	Date	Description
-	2008.07.29	SUBMISSION FOR ADVISORY DESIGN PANEL
-	2008.07.29	ISSUED FOR DP APPLICATION
-	2008.08.08	ISSUED FOR COSTING AND COORDINATION
-	2009.06.25	ISSUED FOR COSTING AND COORDINATION
-	2009.08.14	DESIGN DEVELOPMENT SIGN OFF
-	2010.02.02	AUDP UPDATE
-	2010.03.26	DEVELOPMENT PERMIT

**CONSULTANTS:**

McFarland Marceau Architects Ltd. (including its employees and agents) can take no responsibility for the accuracy or use of any information on this drawing pertaining to existing site conditions, including buildings, services and utilities. It is the responsibility of the person using said information to verify its accuracy. Should any discrepancy with the actual site conditions be found, it must be reported to the Architect, with time being of the essence.

This drawing, as an instrument of service, is the property of McFarland Marceau Architects Ltd. and may not be reproduced without their permission and unless the reproduction carries their name. All designs and other information shown on this drawing are for use on the specified project only and shall not be used otherwise without written permission of this office.

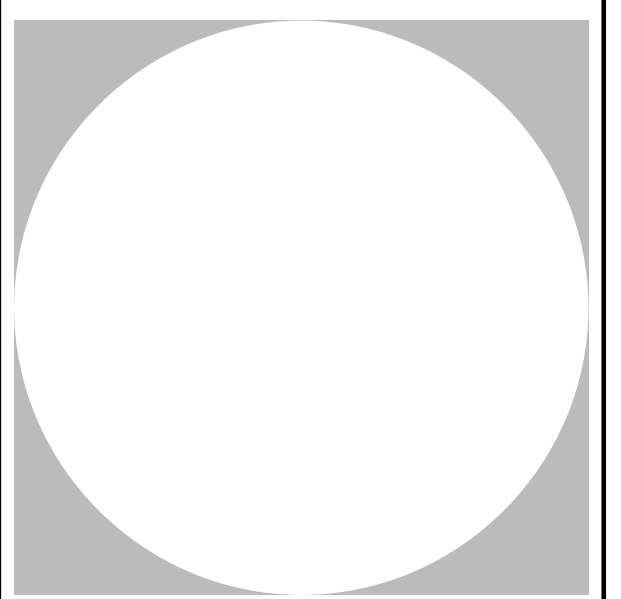

**McFARLAND MARCEAU ARCHITECTS LTD**

programming | planning | architecture

303 - 2930 Arbutus Street  
 Vancouver, BC, V6J 3Y9  
 t. 604 733 1115  
 f. 604 733 9345  
 www.mmal.ca

LMAL Project No.: 0803  
 File name: 0803 CD Plans + Site Plans

**PROJECT TITLE:**  
**WAYNE and WILLIAM WHITE**

**ENGINEERING DESIGN CENTRE UBC**

**PROJECT PHASE:**  
**Dev Permit Documents**


**DRAWING TITLE:**  
**MEZZANINE FLOOR PLAN**

Date Plotted:  
 Scale: 1:75  
 Drawn: FJ  
 Checked:

**DRAWING NUMBER:**  
**A112**



- LEGEND:**
- NOTES:
  - RC RECYCLING CART
  - RD ROOF DRAIN
  - OFS OVERFLOW SCUPPER
  - RWL RAIN WATER LEADER
  - FD FLOOR DRAIN

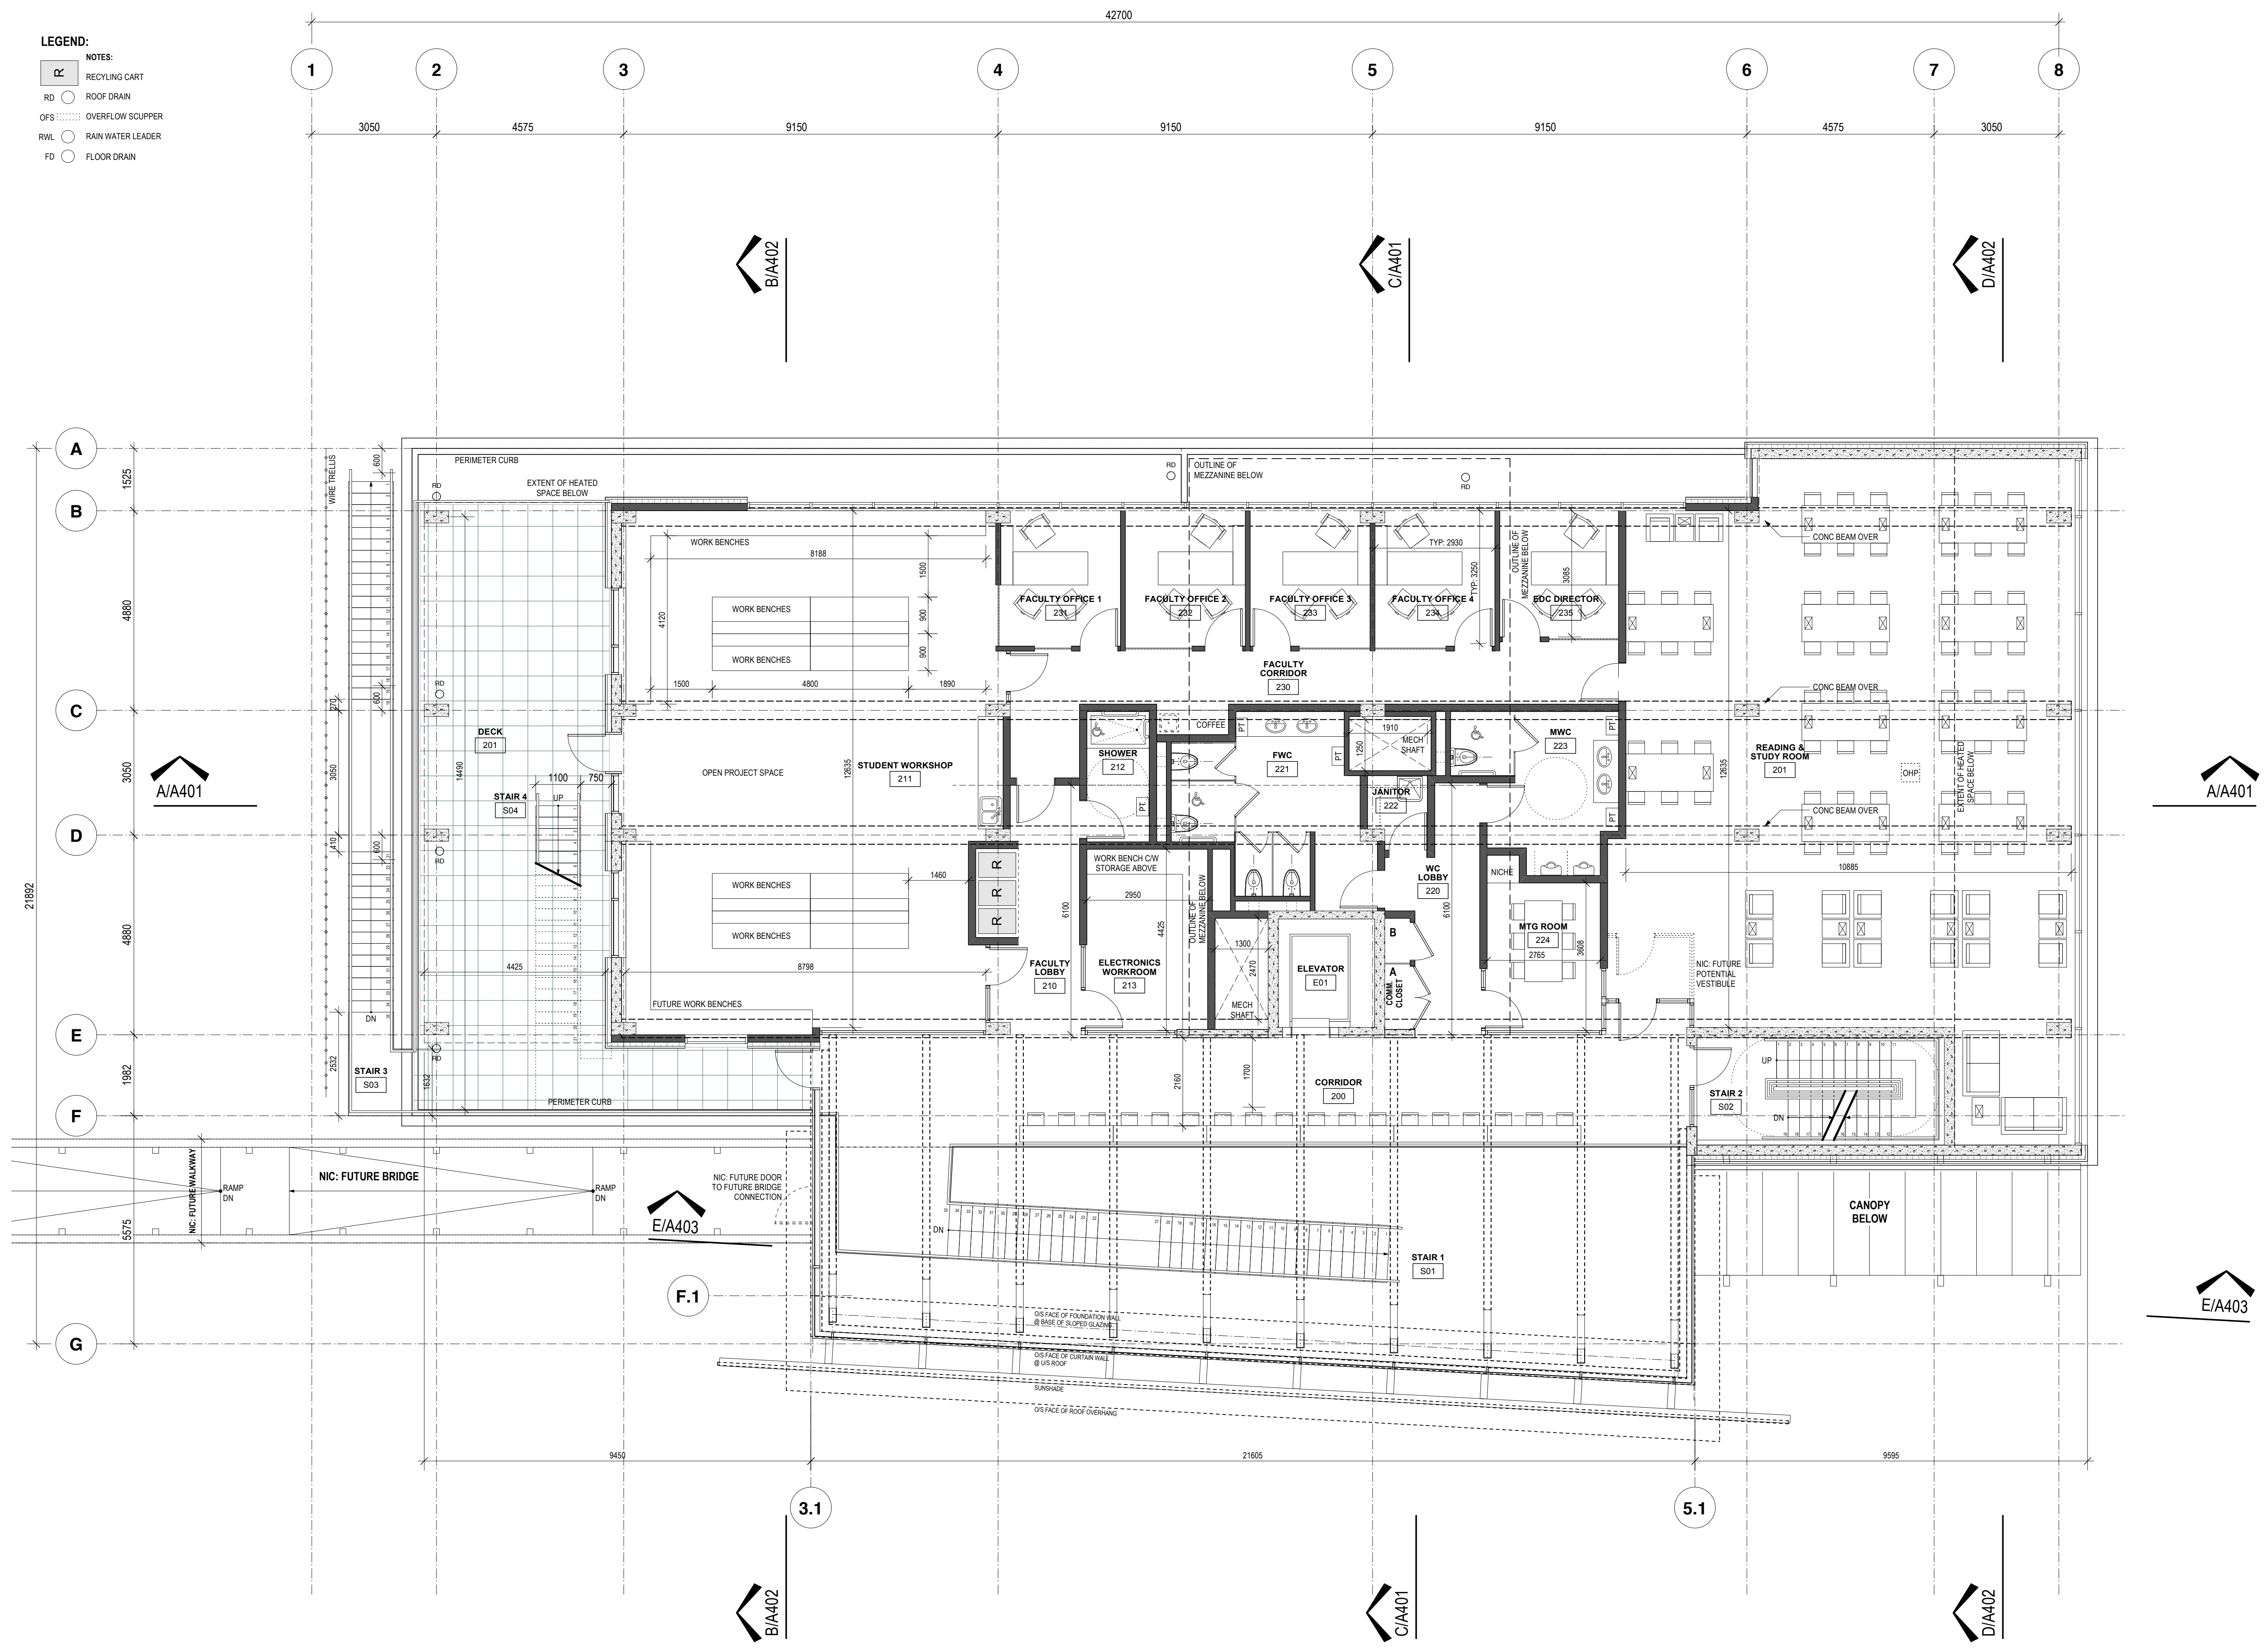


**ISSUE / REVISION:**

No.	Date	Description
-	2008.07.29	SUBMISSION FOR ADVISORY DESIGN PANEL
-	2008.07.29	ISSUED FOR DP APPLICATION
-	2008.08.08	ISSUED FOR COSTING AND COORDINATION
-	2009.06.25	ISSUED FOR COSTING AND COORDINATION
-	2009.08.14	DESIGN DEVELOPMENT SIGN OFF
-	2010.02.02	AUDP UPDATE
-	2010.03.26	DEVELOPMENT PERMIT

**CONSULTANTS:**

McFarland Marceau Architects Ltd. (including its employees and agents) can take no responsibility for the accuracy or use of any information on this drawing pertaining to existing site conditions, including buildings, services and utilities. It is the responsibility of the person using said information to verify its accuracy. Should any discrepancy with the actual site conditions be found, it must be reported to the Architect, with time being of the essence.

This drawing, as an instrument of service, is the property of McFarland Marceau Architects Ltd. and may not be reproduced without their permission and unless the reproduction carries their name. All designs and other information shown on this drawing are for use on the specified project only and shall not be used otherwise without written permission of this office.

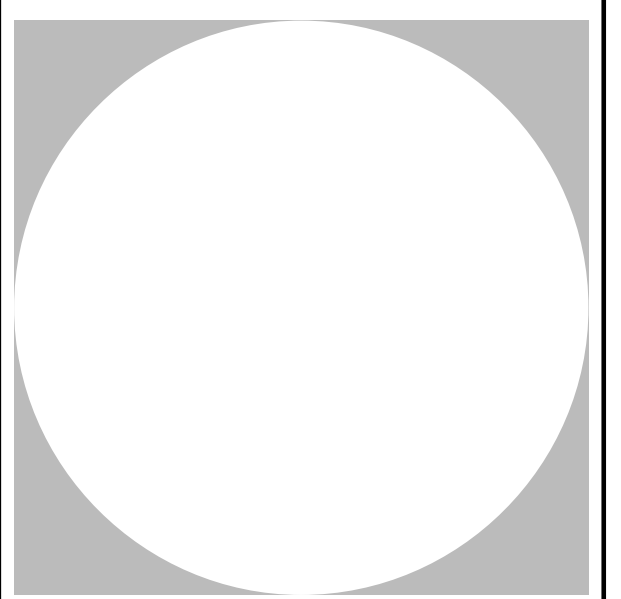

**McFARLAND MARCEAU ARCHITECTS LTD**

programming | planning | architecture

303 - 2930 Arbutus Street  
 Vancouver, BC, V6J 3Y9  
 t. 604 733 1115  
 f. 604 733 9345  
 www.mmal.ca

LMAL Project No.: 0803

File name: 0803 CD Plans + Site Plans

**PROJECT TITLE:**

**WAYNE and WILLIAM WHITE**

**ENGINEERING DESIGN CENTRE UBC**

**PROJECT PHASE:**

**Dev Permit Documents**

**DRAWING TITLE:**


**SECOND FLOOR PLAN**

Date Plotted:  
 Scale: 1:75  
 Drawn: FJ  
 Checked:

**DRAWING NUMBER:**

**A113**

- LEGEND:**
- NOTES:
  - RC RECYCLING CART
  - RD ROOF DRAIN
  - OFS OVERFLOW SCUPPER
  - RWL RAIN WATER LEADER
  - FD FLOOR DRAIN

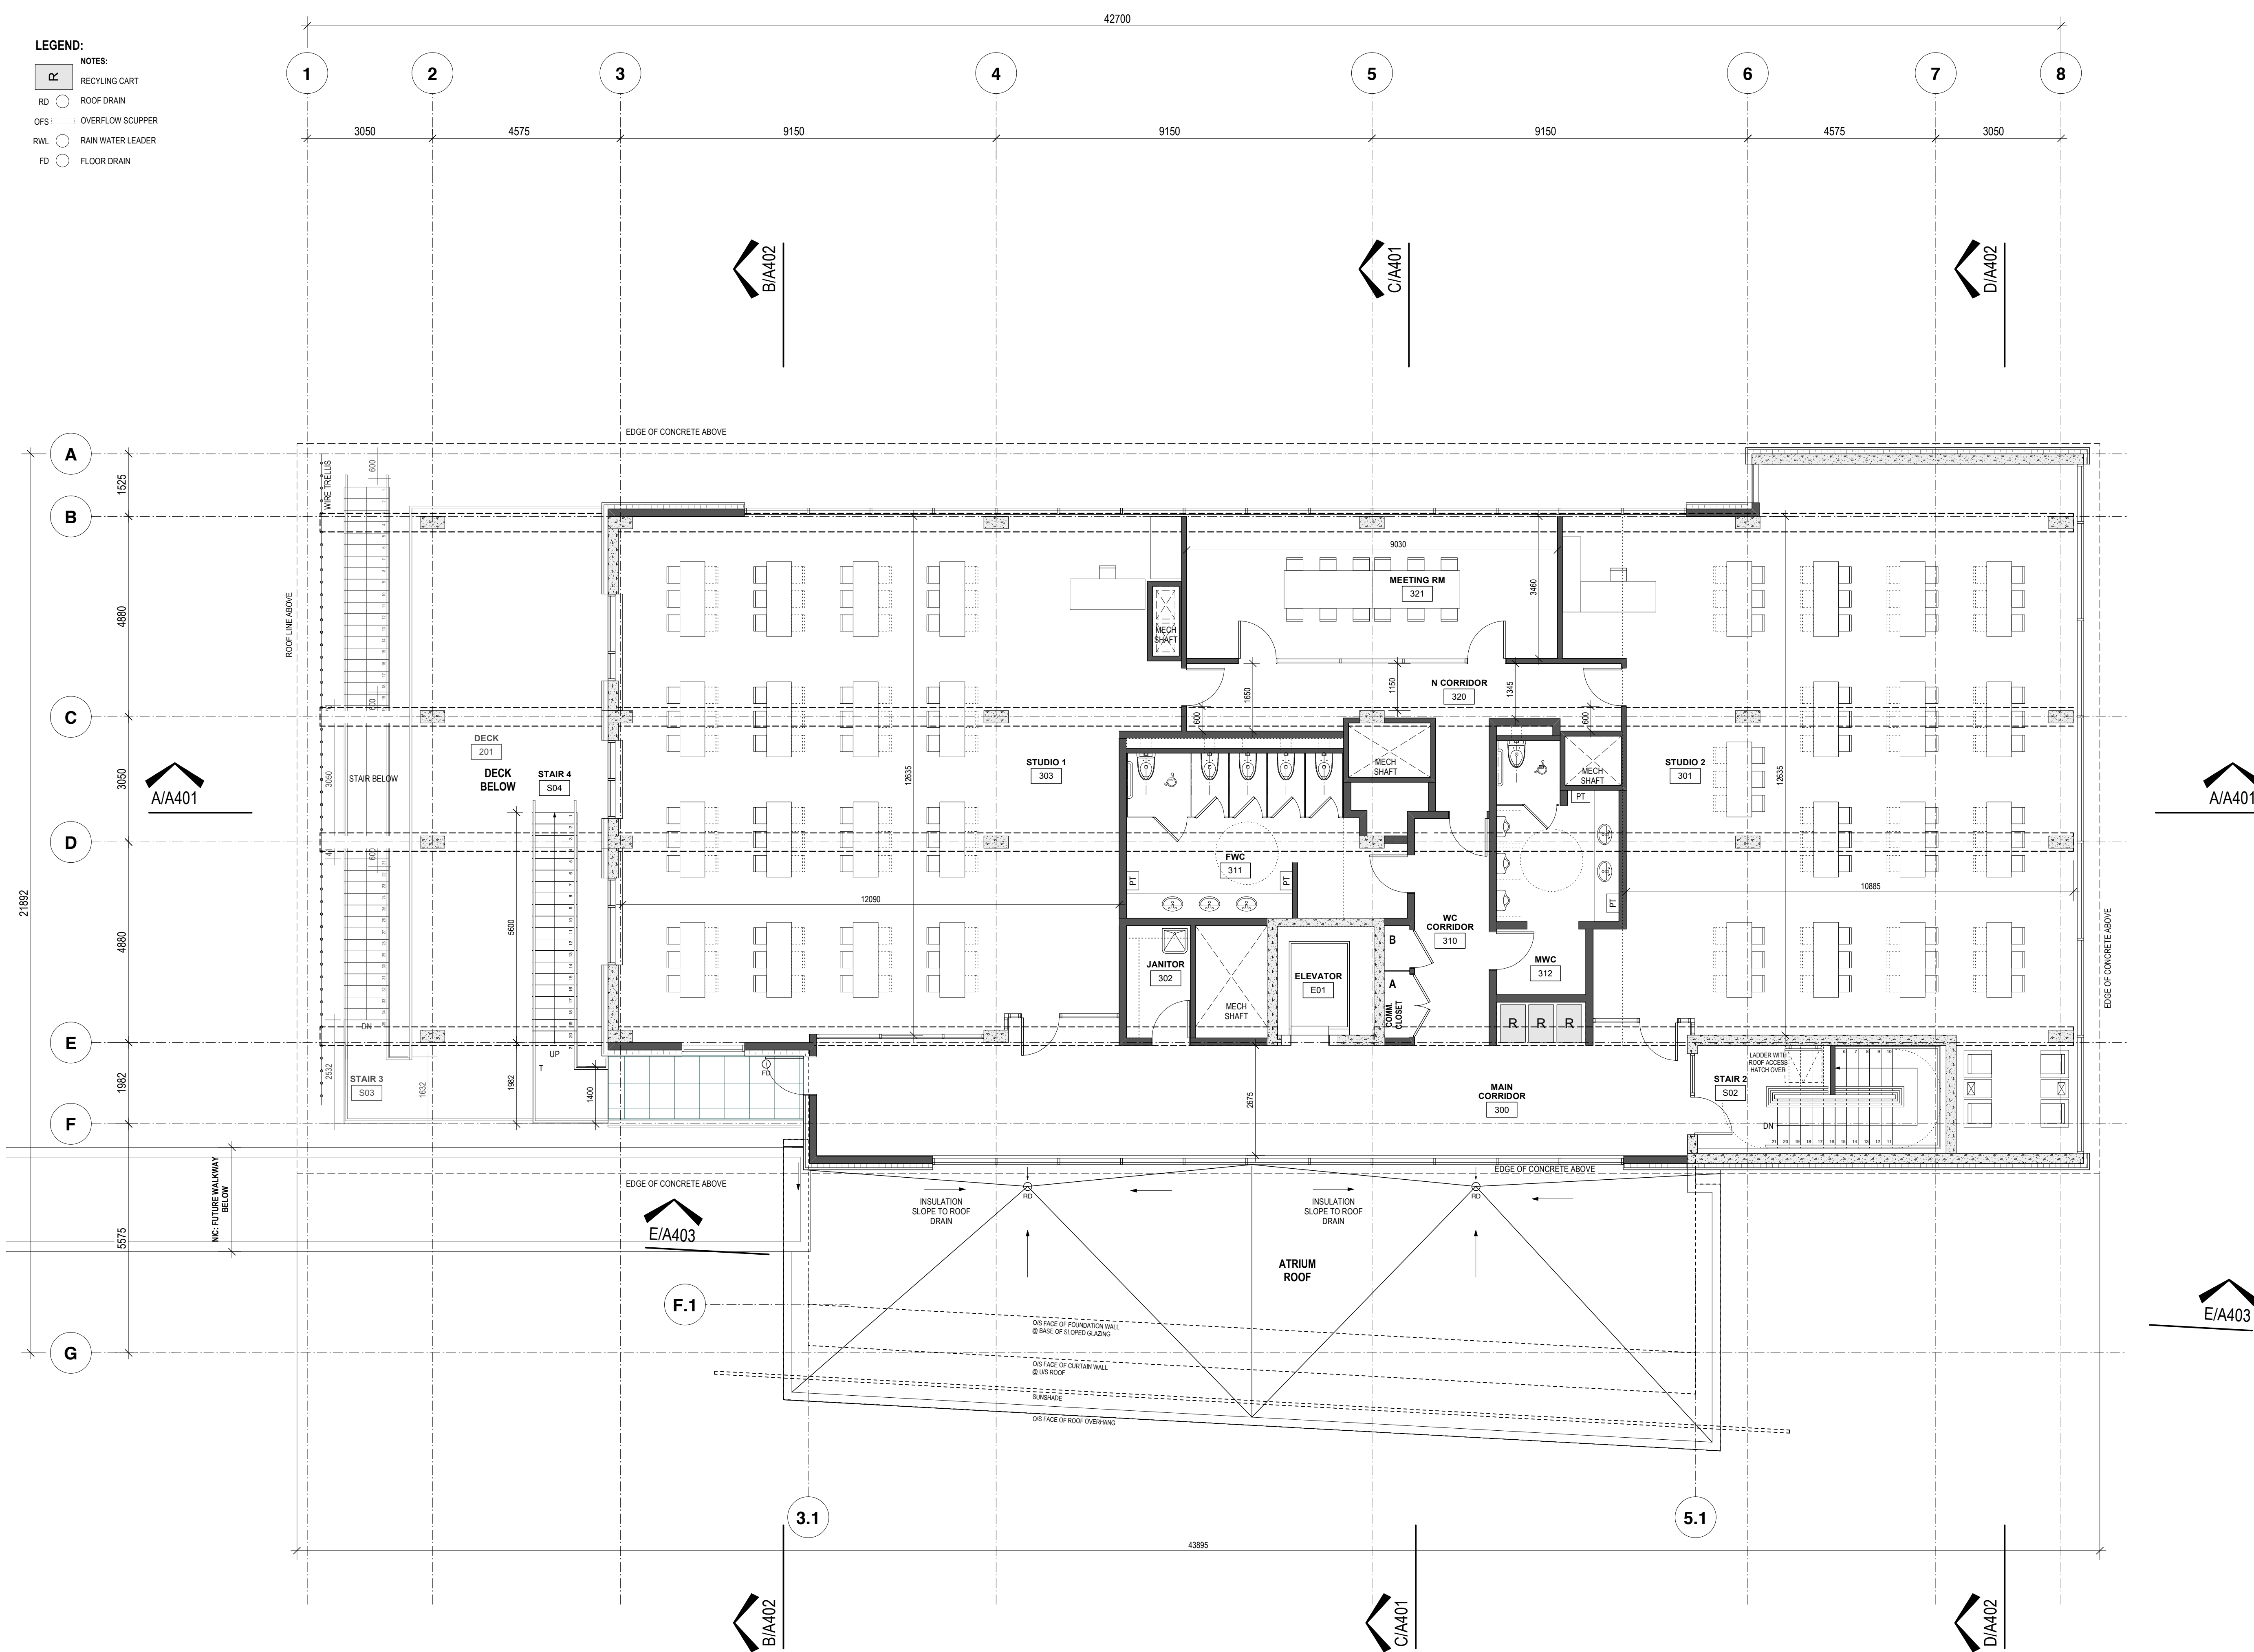


**ISSUE / REVISION:**

No.	Date	Description
-	2008.07.29	SUBMISSION FOR ADVISORY DESIGN PANEL
-	2008.07.29	ISSUED FOR DP APPLICATION
-	2008.08.08	ISSUED FOR COSTING AND COORDINATION
-	2009.06.25	ISSUED FOR COSTING AND COORDINATION
-	2009.08.14	DESIGN DEVELOPMENT SIGN OFF
-	2010.02.02	AUDP UPDATE
-	2010.03.26	DEVELOPMENT PERMIT

**CONSULTANTS:**

McFarland Marceau Architects Ltd. (including its employees and agents) can take no responsibility for the accuracy or use of any information on this drawing pertaining to existing site conditions, including buildings, services and utilities. It is the responsibility of the person using said information to verify its accuracy. Should any discrepancy with the actual site conditions be found, it must be reported to the Architect, with time being of the essence.

This drawing, as an instrument of service, is the property of McFarland Marceau Architects Ltd. and may not be reproduced without their permission and unless the reproduction carries their name. All designs and other information shown on this drawing are for use on the specified project only and shall not be used otherwise without written permission of this office.

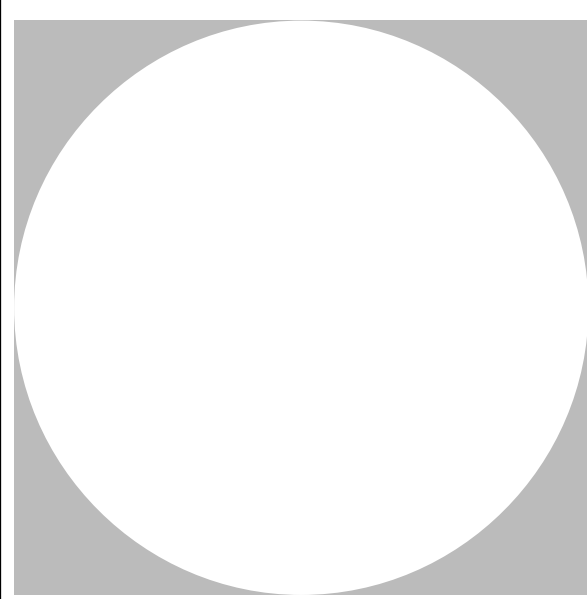

**McFARLAND MARCEAU ARCHITECTS LTD**

programming | planning | architecture

303 - 2930 Arbutus Street  
 Vancouver, BC, V6J 3Y9  
 t. 604 733 1115  
 f. 604 733 9345  
 www.mmal.ca

LMAL Project No.: 0803  
 File name: 0803 CD Plans + Site Plans

**PROJECT TITLE:**  
**WAYNE and WILLIAM WHITE**

**ENGINEERING DESIGN CENTRE UBC**

**PROJECT PHASE:**  
**Dev Permit Documents**


**DRAWING TITLE:**  
**THIRD FLOOR PLAN**

Date Plotted:  
 Scale: 1:75  
 Drawn: FJ  
 Checked:

**DRAWING NUMBER:**  
**A114**



- LEGEND:**
- NOTES:
  - RC RECYCLING CART
  - RD ROOF DRAIN
  - OFS OVERFLOW SCUPPER
  - RWL RAIN WATER LEADER
  - FD FLOOR DRAIN

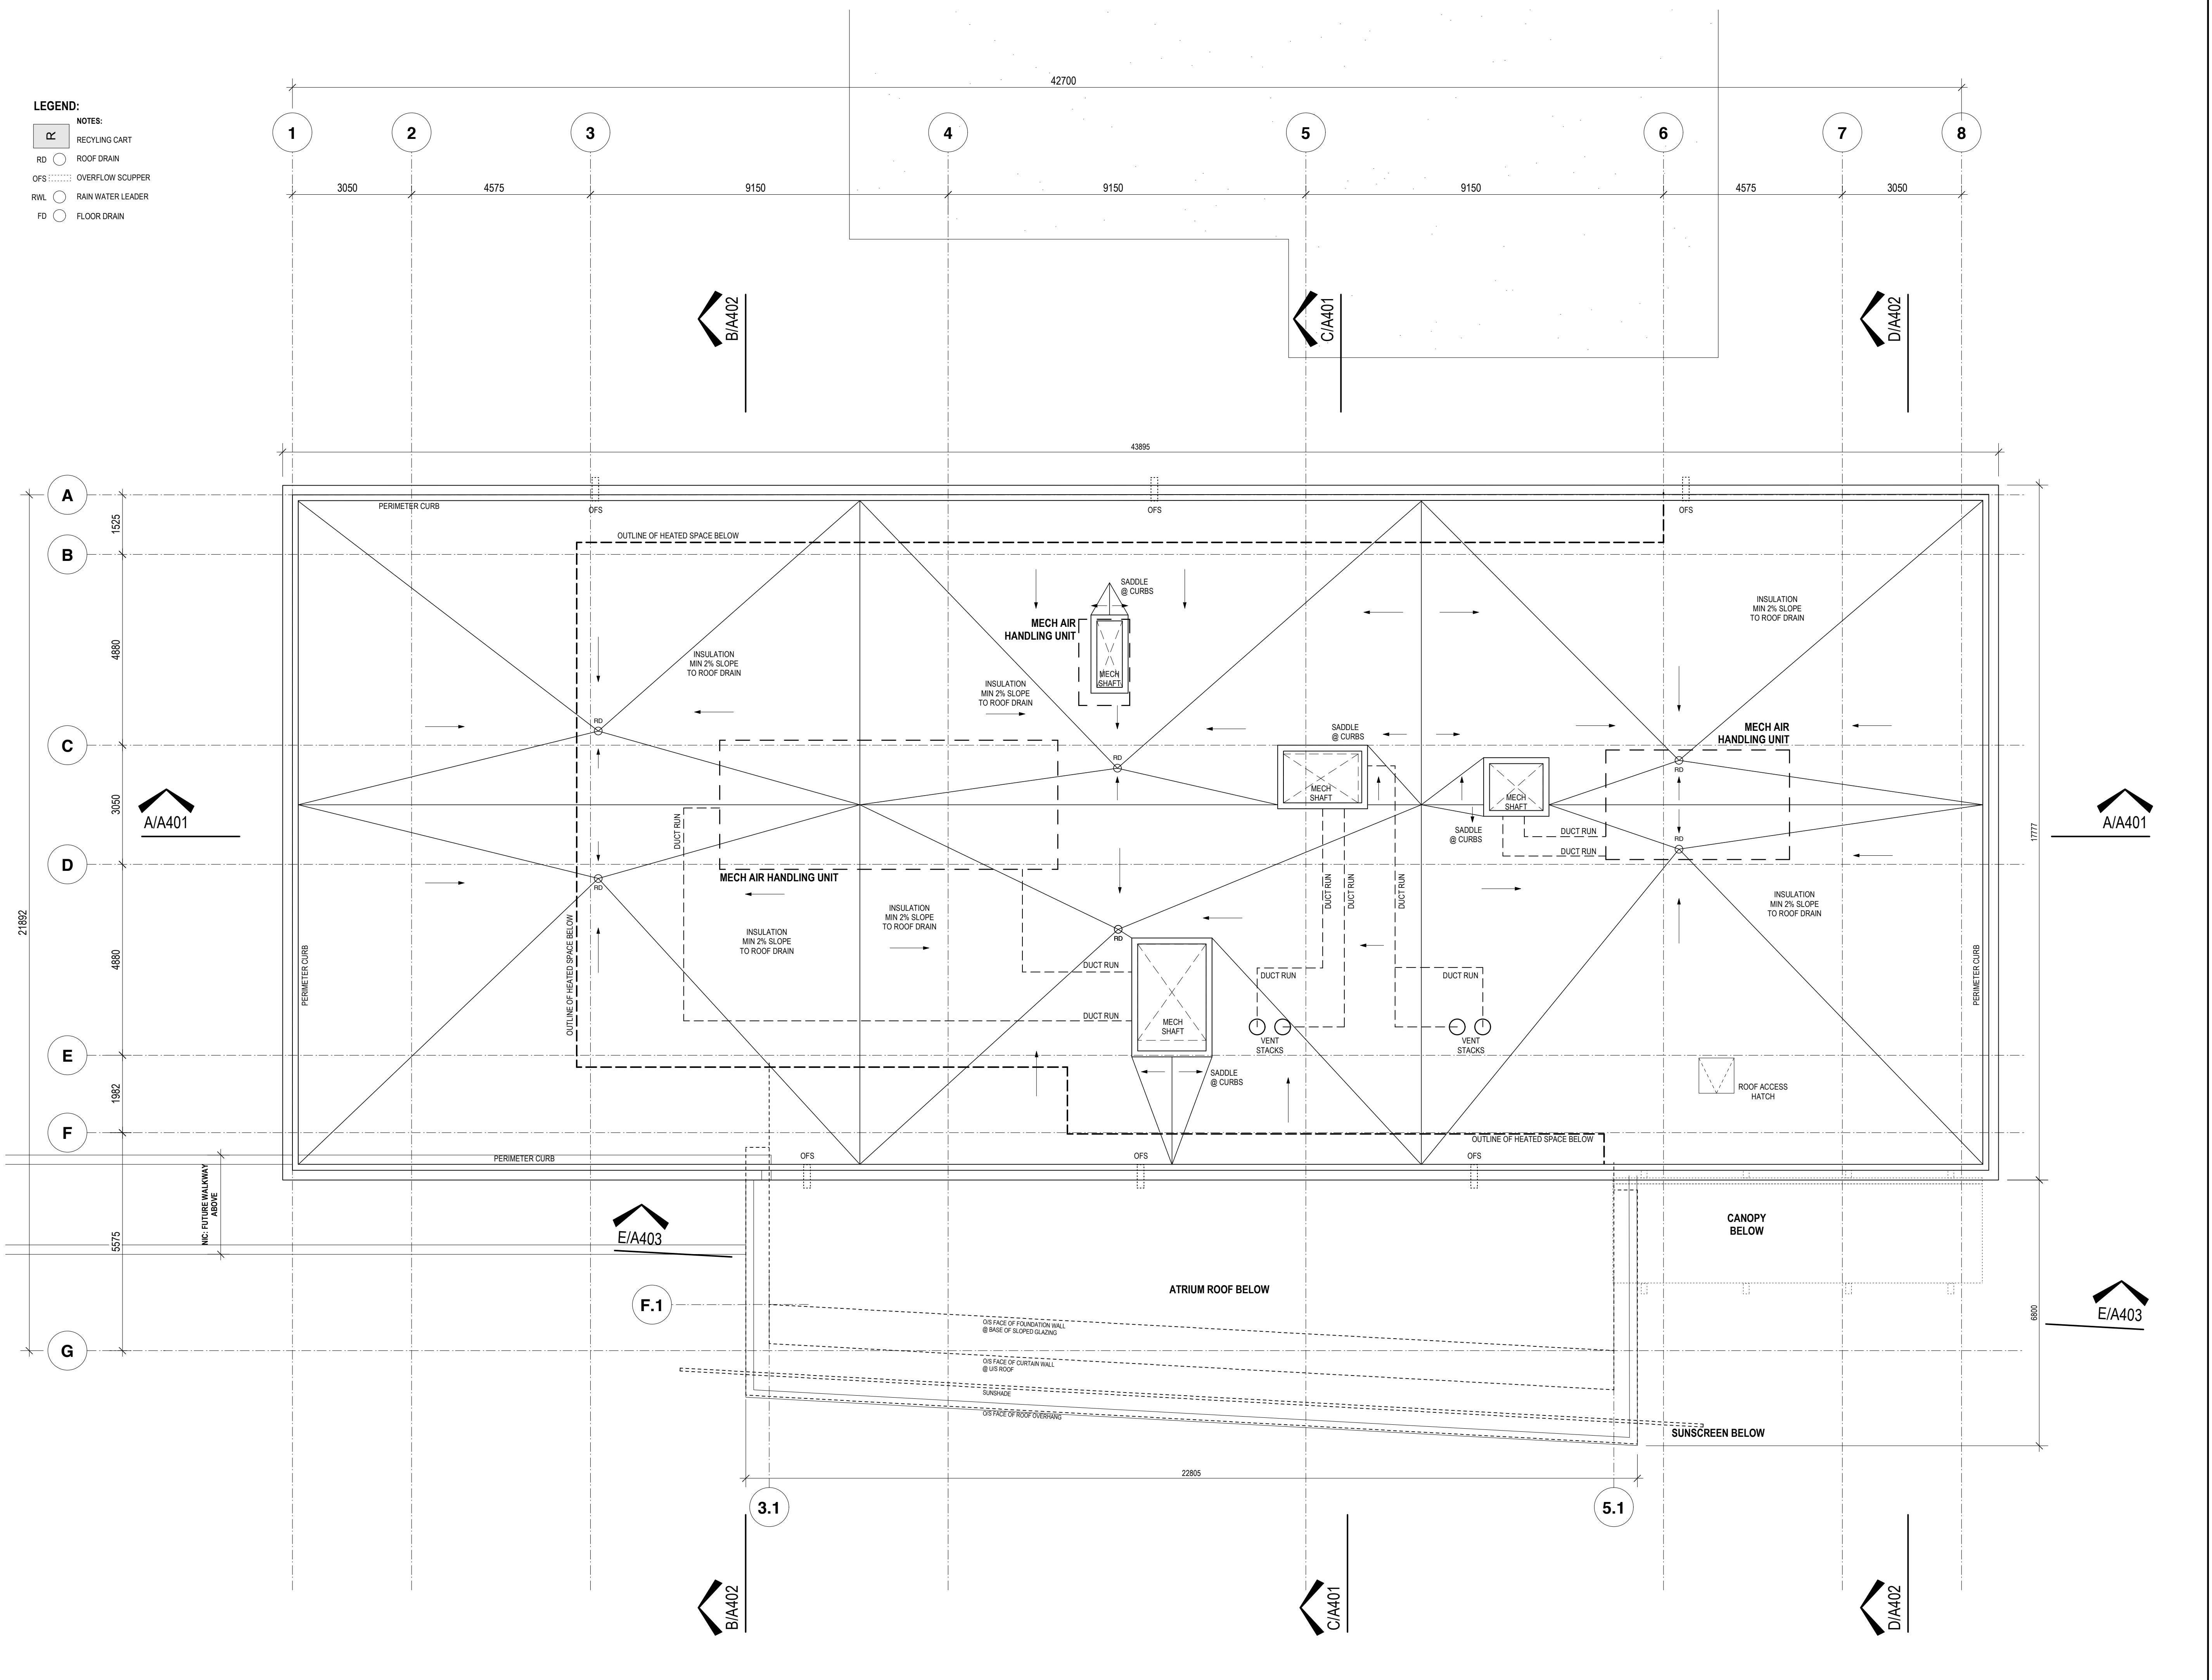


**ISSUE / REVISION:**

No.	Date	Description
-	2008.07.29	SUBMISSION FOR ADVISORY DESIGN PANEL
-	2008.07.29	ISSUED FOR DP APPLICATION
-	2008.08.08	ISSUED FOR COSTING AND COORDINATION
-	2009.06.25	ISSUED FOR COSTING AND COORDINATION
-	2009.08.14	DESIGN DEVELOPMENT SIGN OFF
-	2010.02.02	AUDP UPDATE
-	2010.03.26	DEVELOPMENT PERMIT

**CONSULTANTS:**

McFarland Marceau Architects Ltd. (including its employees and agents) can take no responsibility for the accuracy or use of any information on this drawing pertaining to existing site conditions, including buildings, services and utilities. It is the responsibility of the person using said information to verify its accuracy. Should any discrepancy with the actual site conditions be found, it must be reported to the Architect, with time being of the essence.

This drawing, as an instrument of service, is the property of McFarland Marceau Architects Ltd. and may not be reproduced without their permission and unless the reproduction carries their name. All designs and other information shown on this drawing are for use on the specified project only and shall not be used otherwise without written permission of this office.

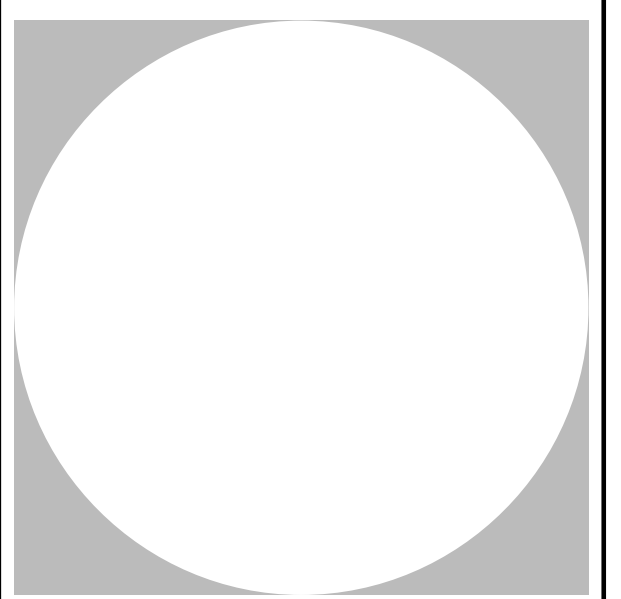

**McFARLAND MARCEAU ARCHITECTS LTD**

programming | planning | architecture

303 - 2930 Arbutus Street  
 Vancouver, BC, V6J 3Y9  
 t. 604 733 1115  
 f. 604 733 9345  
 www.mmal.ca

LMAL Project No.: 0803

File name: 0803 CD Plans + Site Plans

**PROJECT TITLE:**

**WAYNE and WILLIAM WHITE**

**ENGINEERING DESIGN CENTRE UBC**

**PROJECT PHASE:**

**Dev Permit Documents**

**DRAWING TITLE:**

**ROOF PLAN**

Date Plotted:  
 Scale: 1:75  
 Drawn: FJ  
 Checked:

**DRAWING NUMBER:**

**A105**