



1 CONTEXT PLAN
1:1000

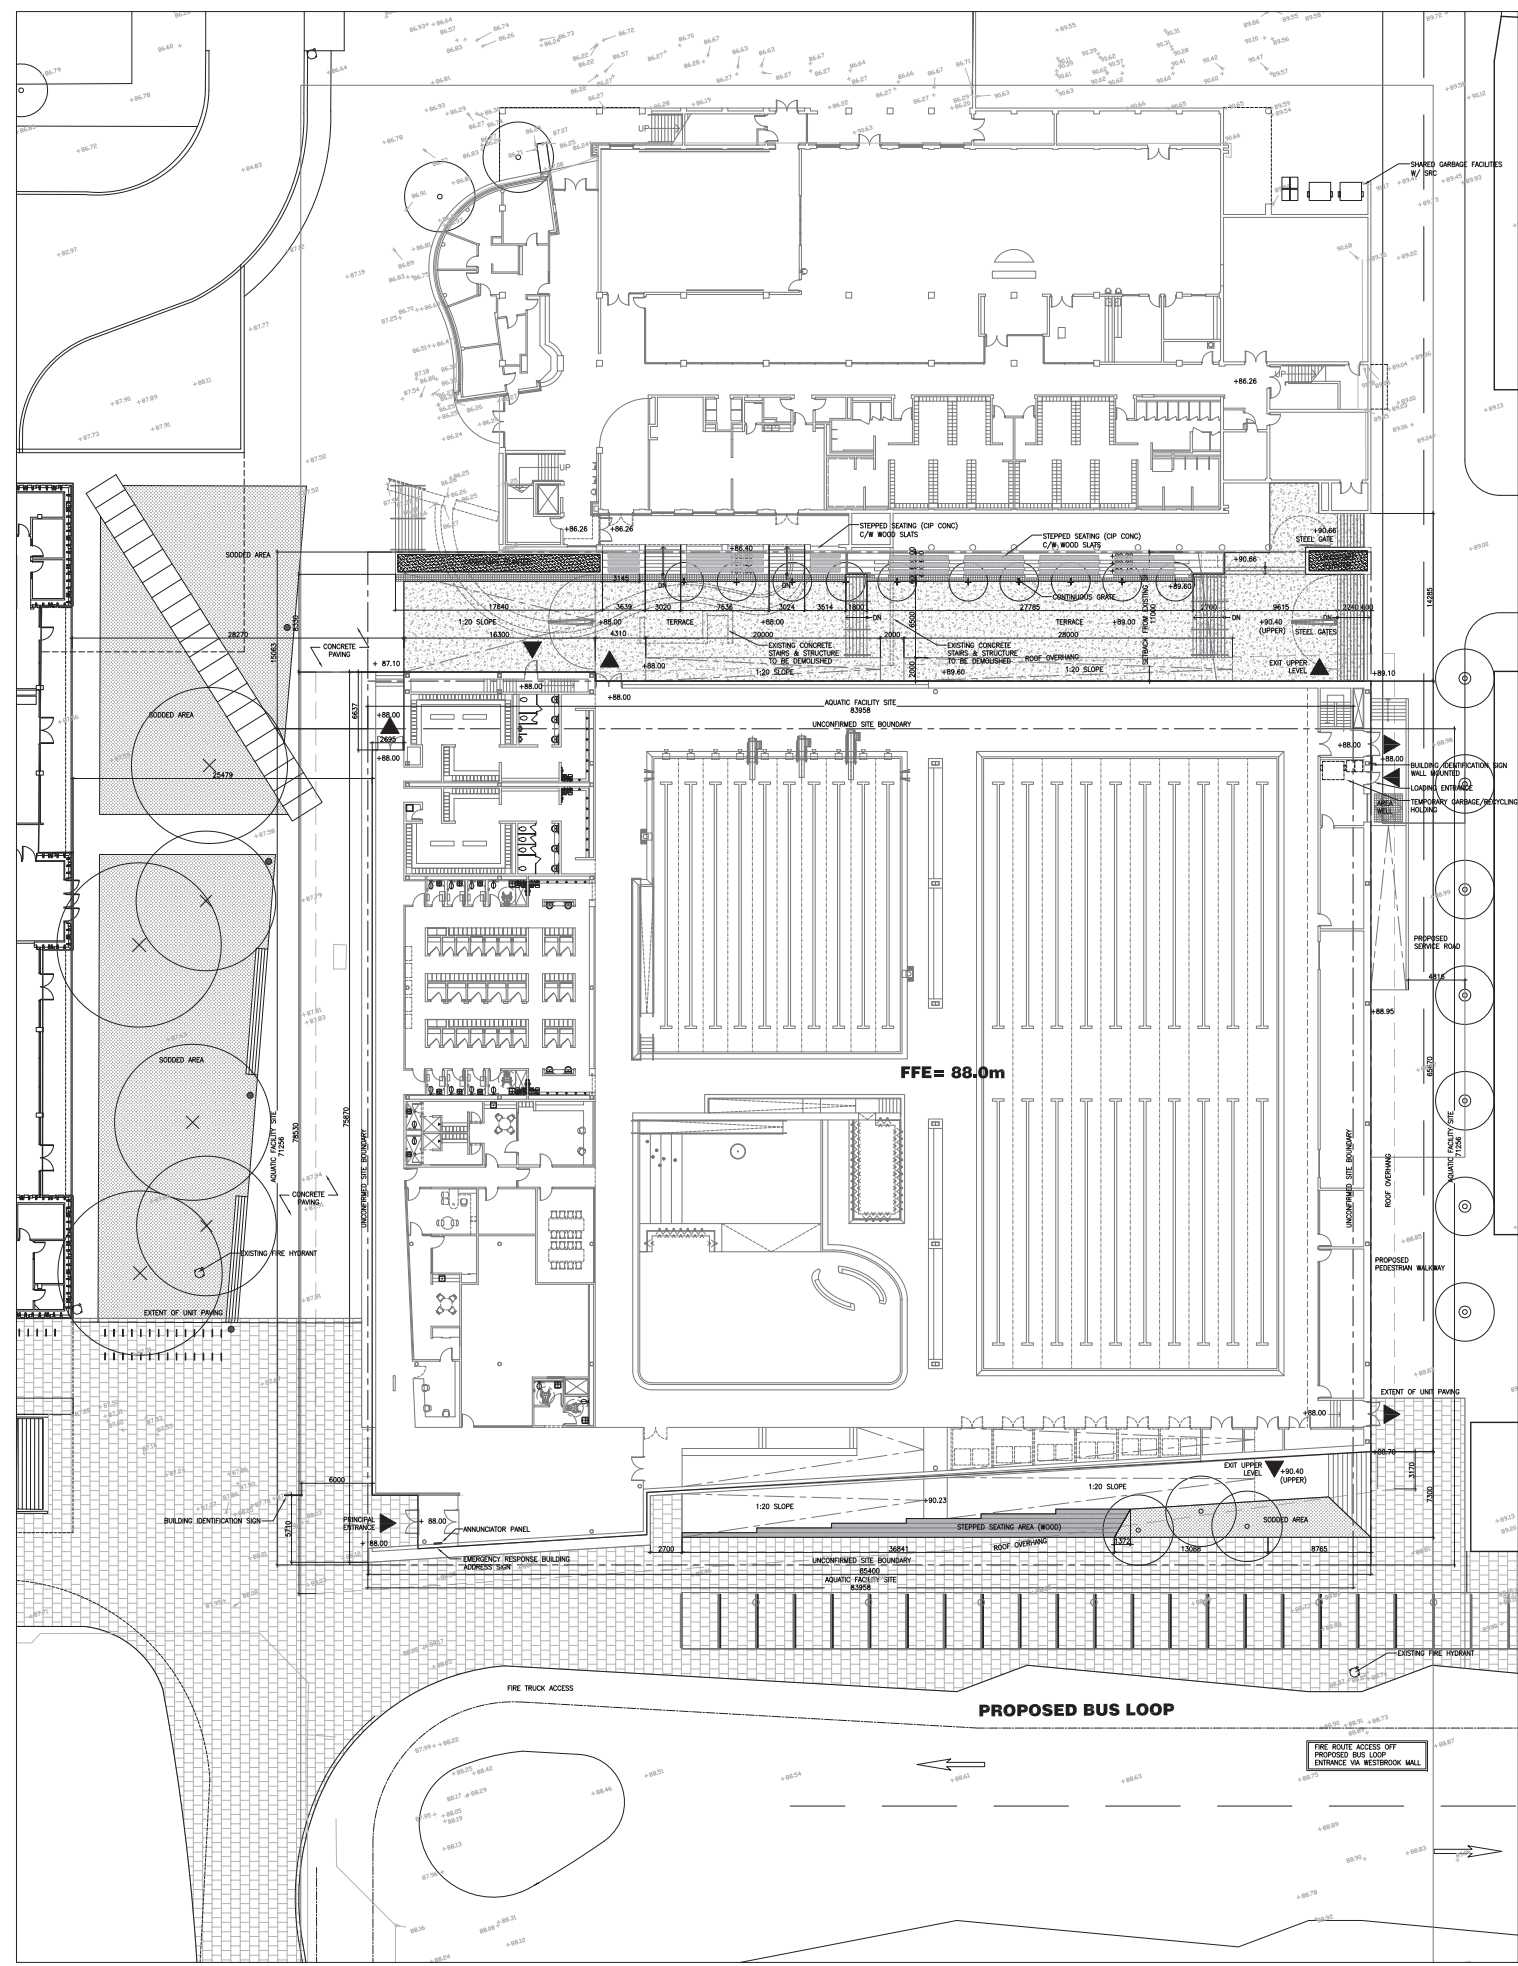

3 SITE PLAN
1:200

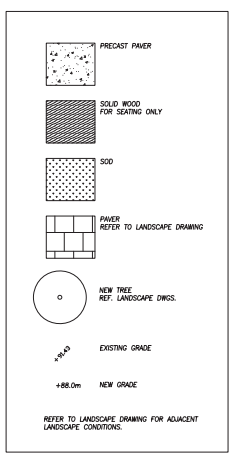

2 LEGEND

Contractor must check and verify all dimensions on the job, and report any discrepancies to the architect before proceeding with the work. Do not scale this drawing.

| REV | DESCRIPTION | DATE | BY |
|-----|-------------------------------|-------------|---------|
| 1 | ISSUED FOR DEVELOPMENT PERMIT | APR 25/2013 | AJA/KAM |
| 2 | | | |
| 3 | | | |
| 4 | | | |
| 5 | | | |
| 6 | | | |
| 7 | | | |
| 8 | | | |

MJMA + AOA
ARCHITECTS

KAMPS ENGINEERING LTD.
CIVIL ENGINEERS

PHILLIPS FARVYAG SMALLBERG
LANDSCAPE ARCHITECTS

EQUILIBRIUM
STRUCTURAL ENGINEERS

AME CONSULTING GROUP
MECHANICAL ENGINEERS

APPLIED ENGINEERING SOLUTIONS
ELECTRICAL ENGINEERS


WTI TECHNOLOGIES
ARCHITECTURAL CONSULTANTS

LDWG
CODE CONSULTANTS

RECOLLECTIVE
Landscape Architecture

DANIEL LYZUN & ASSOCIATES
ARCHITECTURAL CONSULTANTS

UNIVERSITY OF BRITISH COLUMBIA
2208 WEST MALL
VANCOUVER, BC CANADA V6T 1Z4
T: 604.822.2211

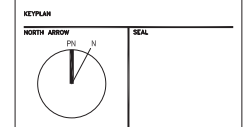


PROJECT TITLE
UBC AQUATIC CENTRE

DRAWING TITLE
SITE PLAN & CONTEXT PLAN

SCALE
1:200

DATE
APRIL 2013

PROJECT NUMBER
1208
DRAWING NUMBER
A001

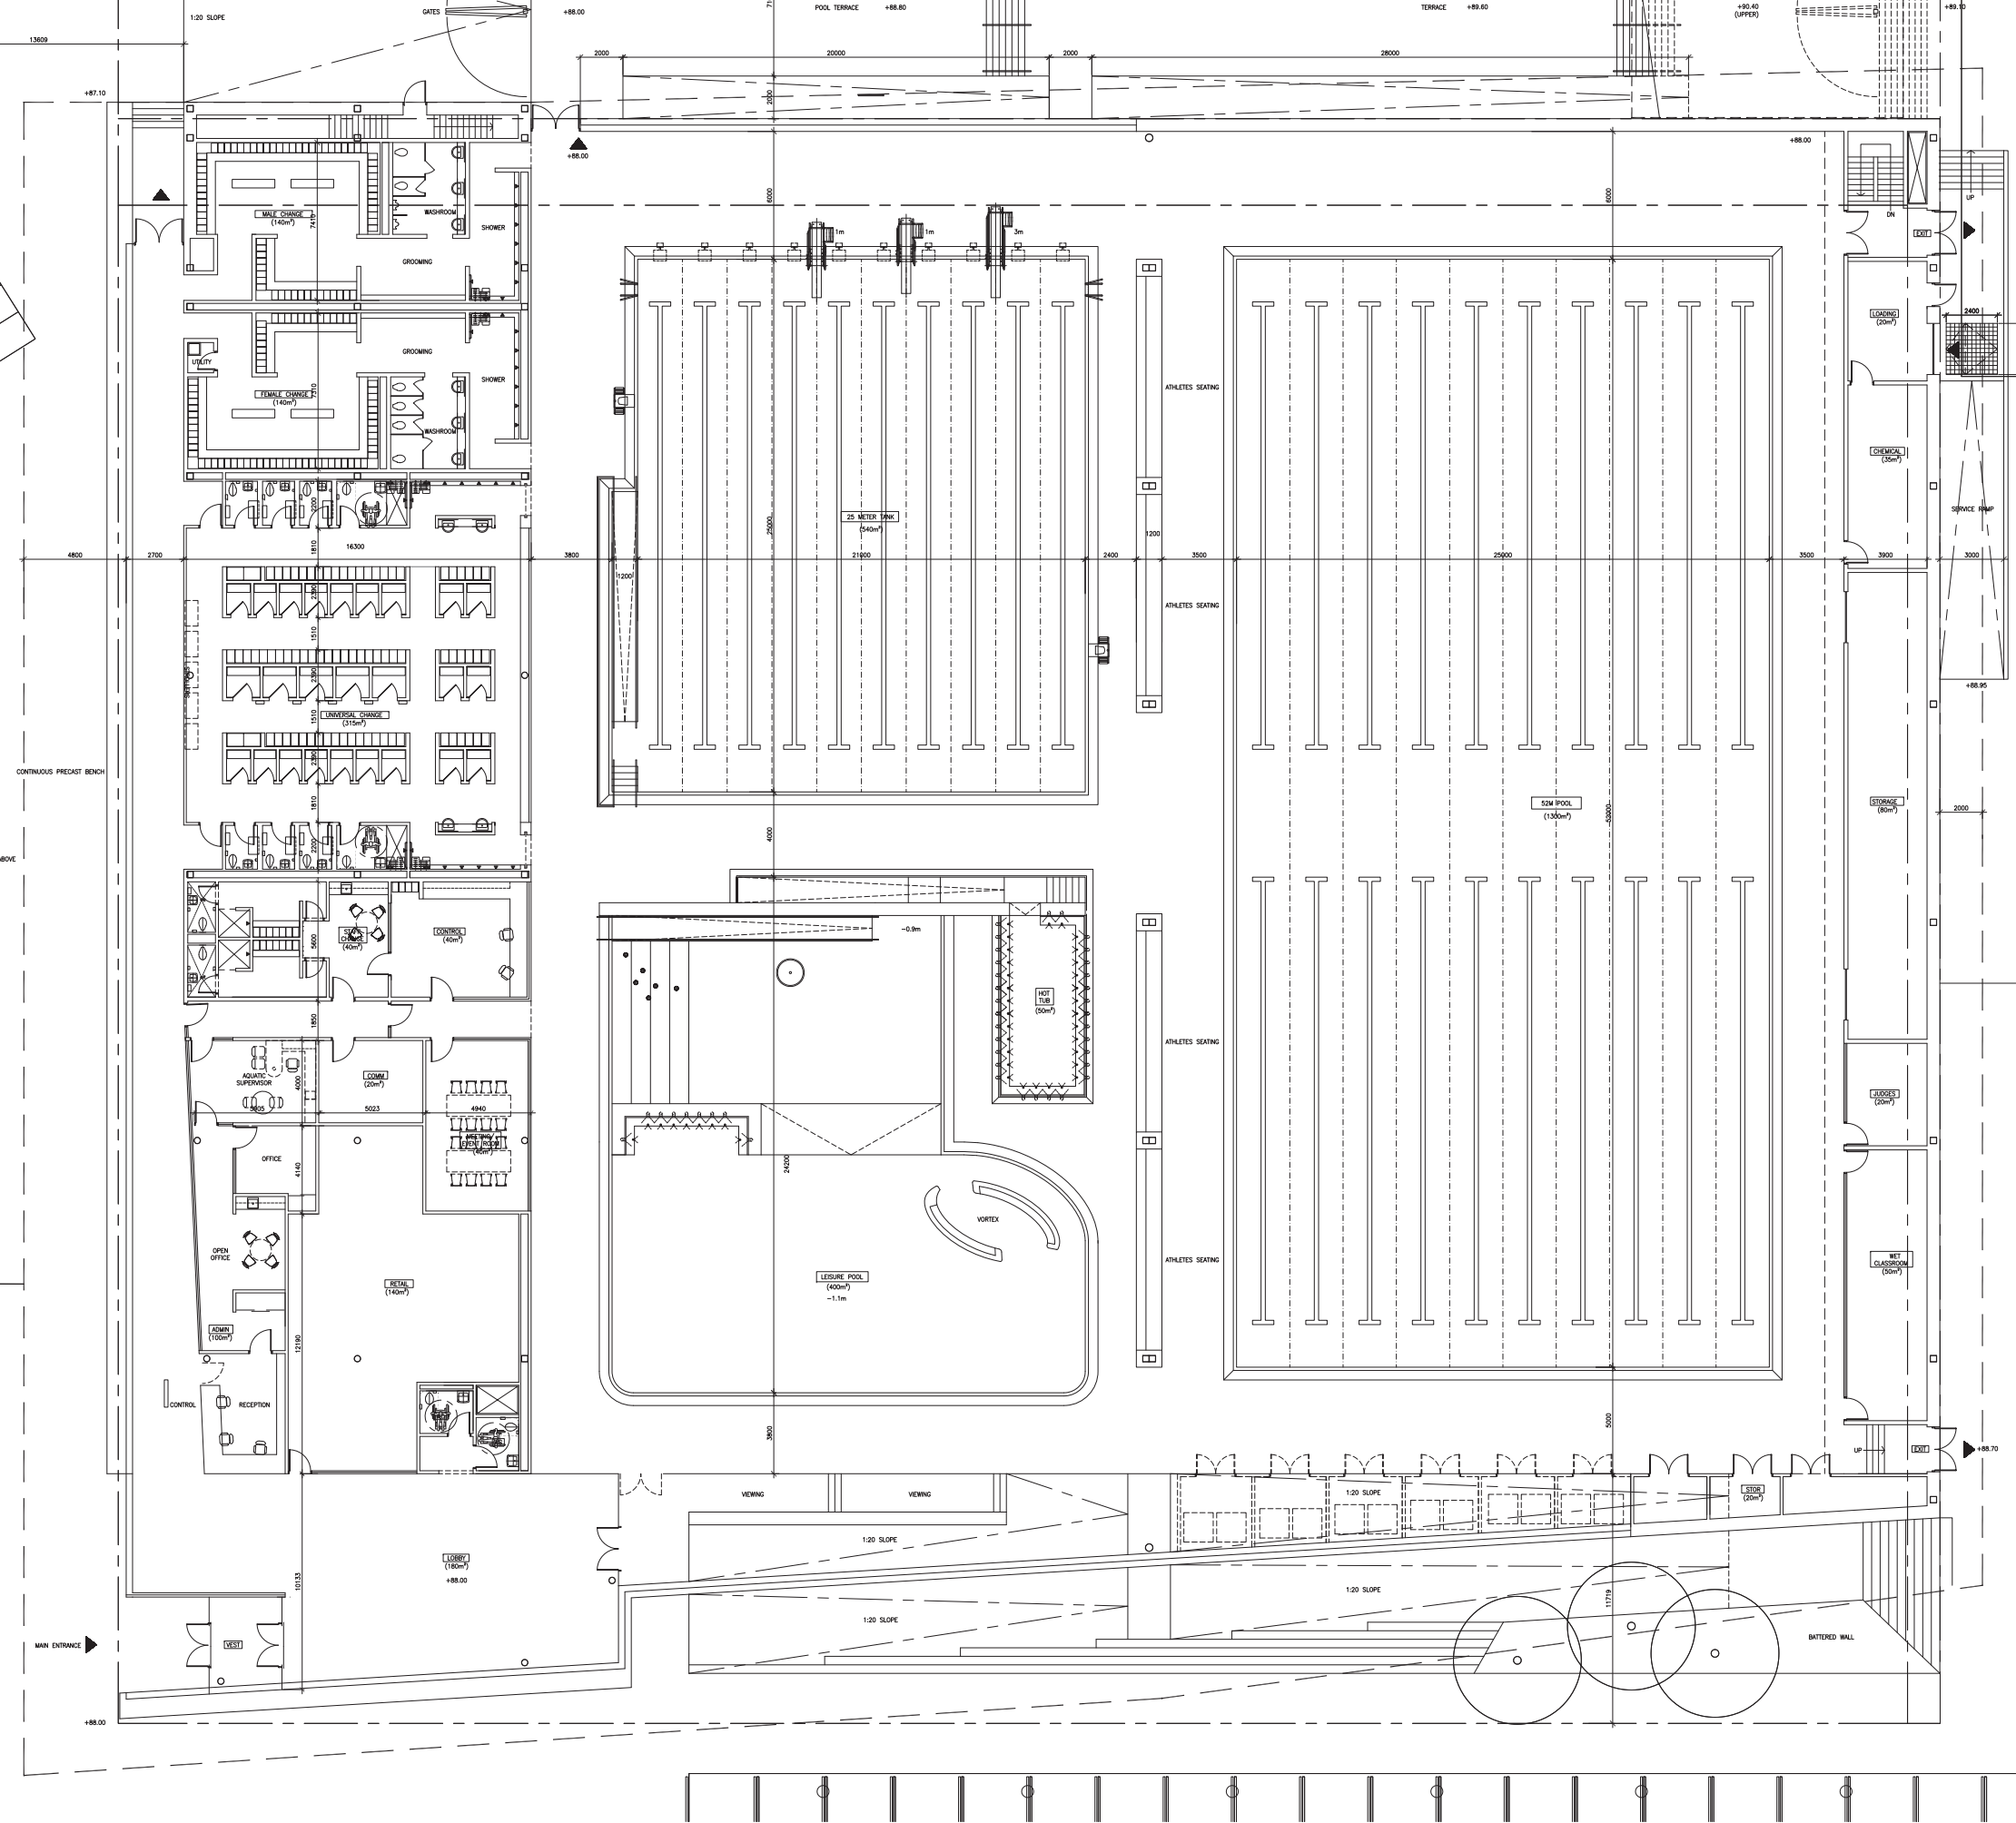

1 GROUND FLOOR PLAN
1:100

Contractor must check and verify all dimensions on the job, and report any discrepancies to the architect before proceeding with the work.
Do not scale this drawing.

| REVISIONS AND ISSUES | DATE | BY |
|---------------------------------|-------------|---------|
| 1 ISSUED FOR DEVELOPMENT PERMIT | APR 25/2013 | AJA/KAM |
| 2 | | |
| 3 | | |
| 4 | | |
| 5 | | |
| 6 | | |
| 7 | | |
| 8 | | |

MJMA + AOA

ARCHITECTS

KAMPS ENGINEERING LTD.
CIVIL ENGINEERS
79 CHESTER AVE.
TORONTO, ON M4R 1K7
TEL: (416) 464-8002

PHILLIPS FARCYANG SMALLENBERG
LANDSCAPE ARCHITECTS
1777 WEST 3rd AVE.
VANCOUVER, BC V6J 1K7
TEL: (604) 738-5148 FAX: (604) 738-5147

EQUILIBRIUM
STRUCTURAL ENGINEERS
202-108 W 6th AVENUE
VANCOUVER, BC V6T 3J2
TEL: (604) 251-1142 FAX: (604) 738-8191

AME CONSULTING GROUP
MECHANICAL ENGINEERS
501-134 ARBUTT STREET
VANCOUVER, BC V6B 2A4
TEL: (604) 494-5995 FAX: (604) 494-5993

APPLIED ENGINEERING SOLUTIONS
ELECTRICAL ENGINEERS
808-608 WEST PENDER STREET
VANCOUVER, BC V6C 1L6
TEL: (604) 388-8900 FAX: (604) 388-8911


WTI TECHNOLOGIES
MECHANICAL CONSULTANTS
100 PARK AVENUE
BURNABY, BC V5A 1S4 52916
TEL: (604) 291-7333 FAX: (604) 291-7995

LDWG
CODE CONSULTANTS
4th FLOOR - 780 BENTLEY ST.
VANCOUVER, BC V6B 2A1
TEL: (604) 462-7142 FAX: (604) 462-7145

RECOLLECTIVE
LEED/GREENWASH CONSULTANTS
210-128 WEST HASTINGS STREET
VANCOUVER, BC V6B 1Z8
TEL: (604) 683-8942 FAX: (604) 683-8943

DANIEL LYZUN & ASSOCIATES
MECHANICAL CONSULTANTS
267-801 WEST 3rd STREET
NORTH VANCOUVER, BC V7P 3P9
TEL: (604) 966-6552

UNIVERSITY OF BRITISH COLUMBIA
2228 WEST MALL
VANCOUVER, BC CANADA V6T 1Z4
T: 604.822.2211

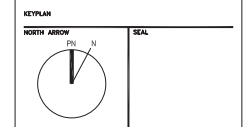


PROJECT TITLE
UBC AQUATIC CENTRE

DRAWING TITLE
GROUND FLOOR PLAN

SCALE
1:100

DATE
APRIL 2013

PROJECT NUMBER
1208
DRAWING NUMBER
A100

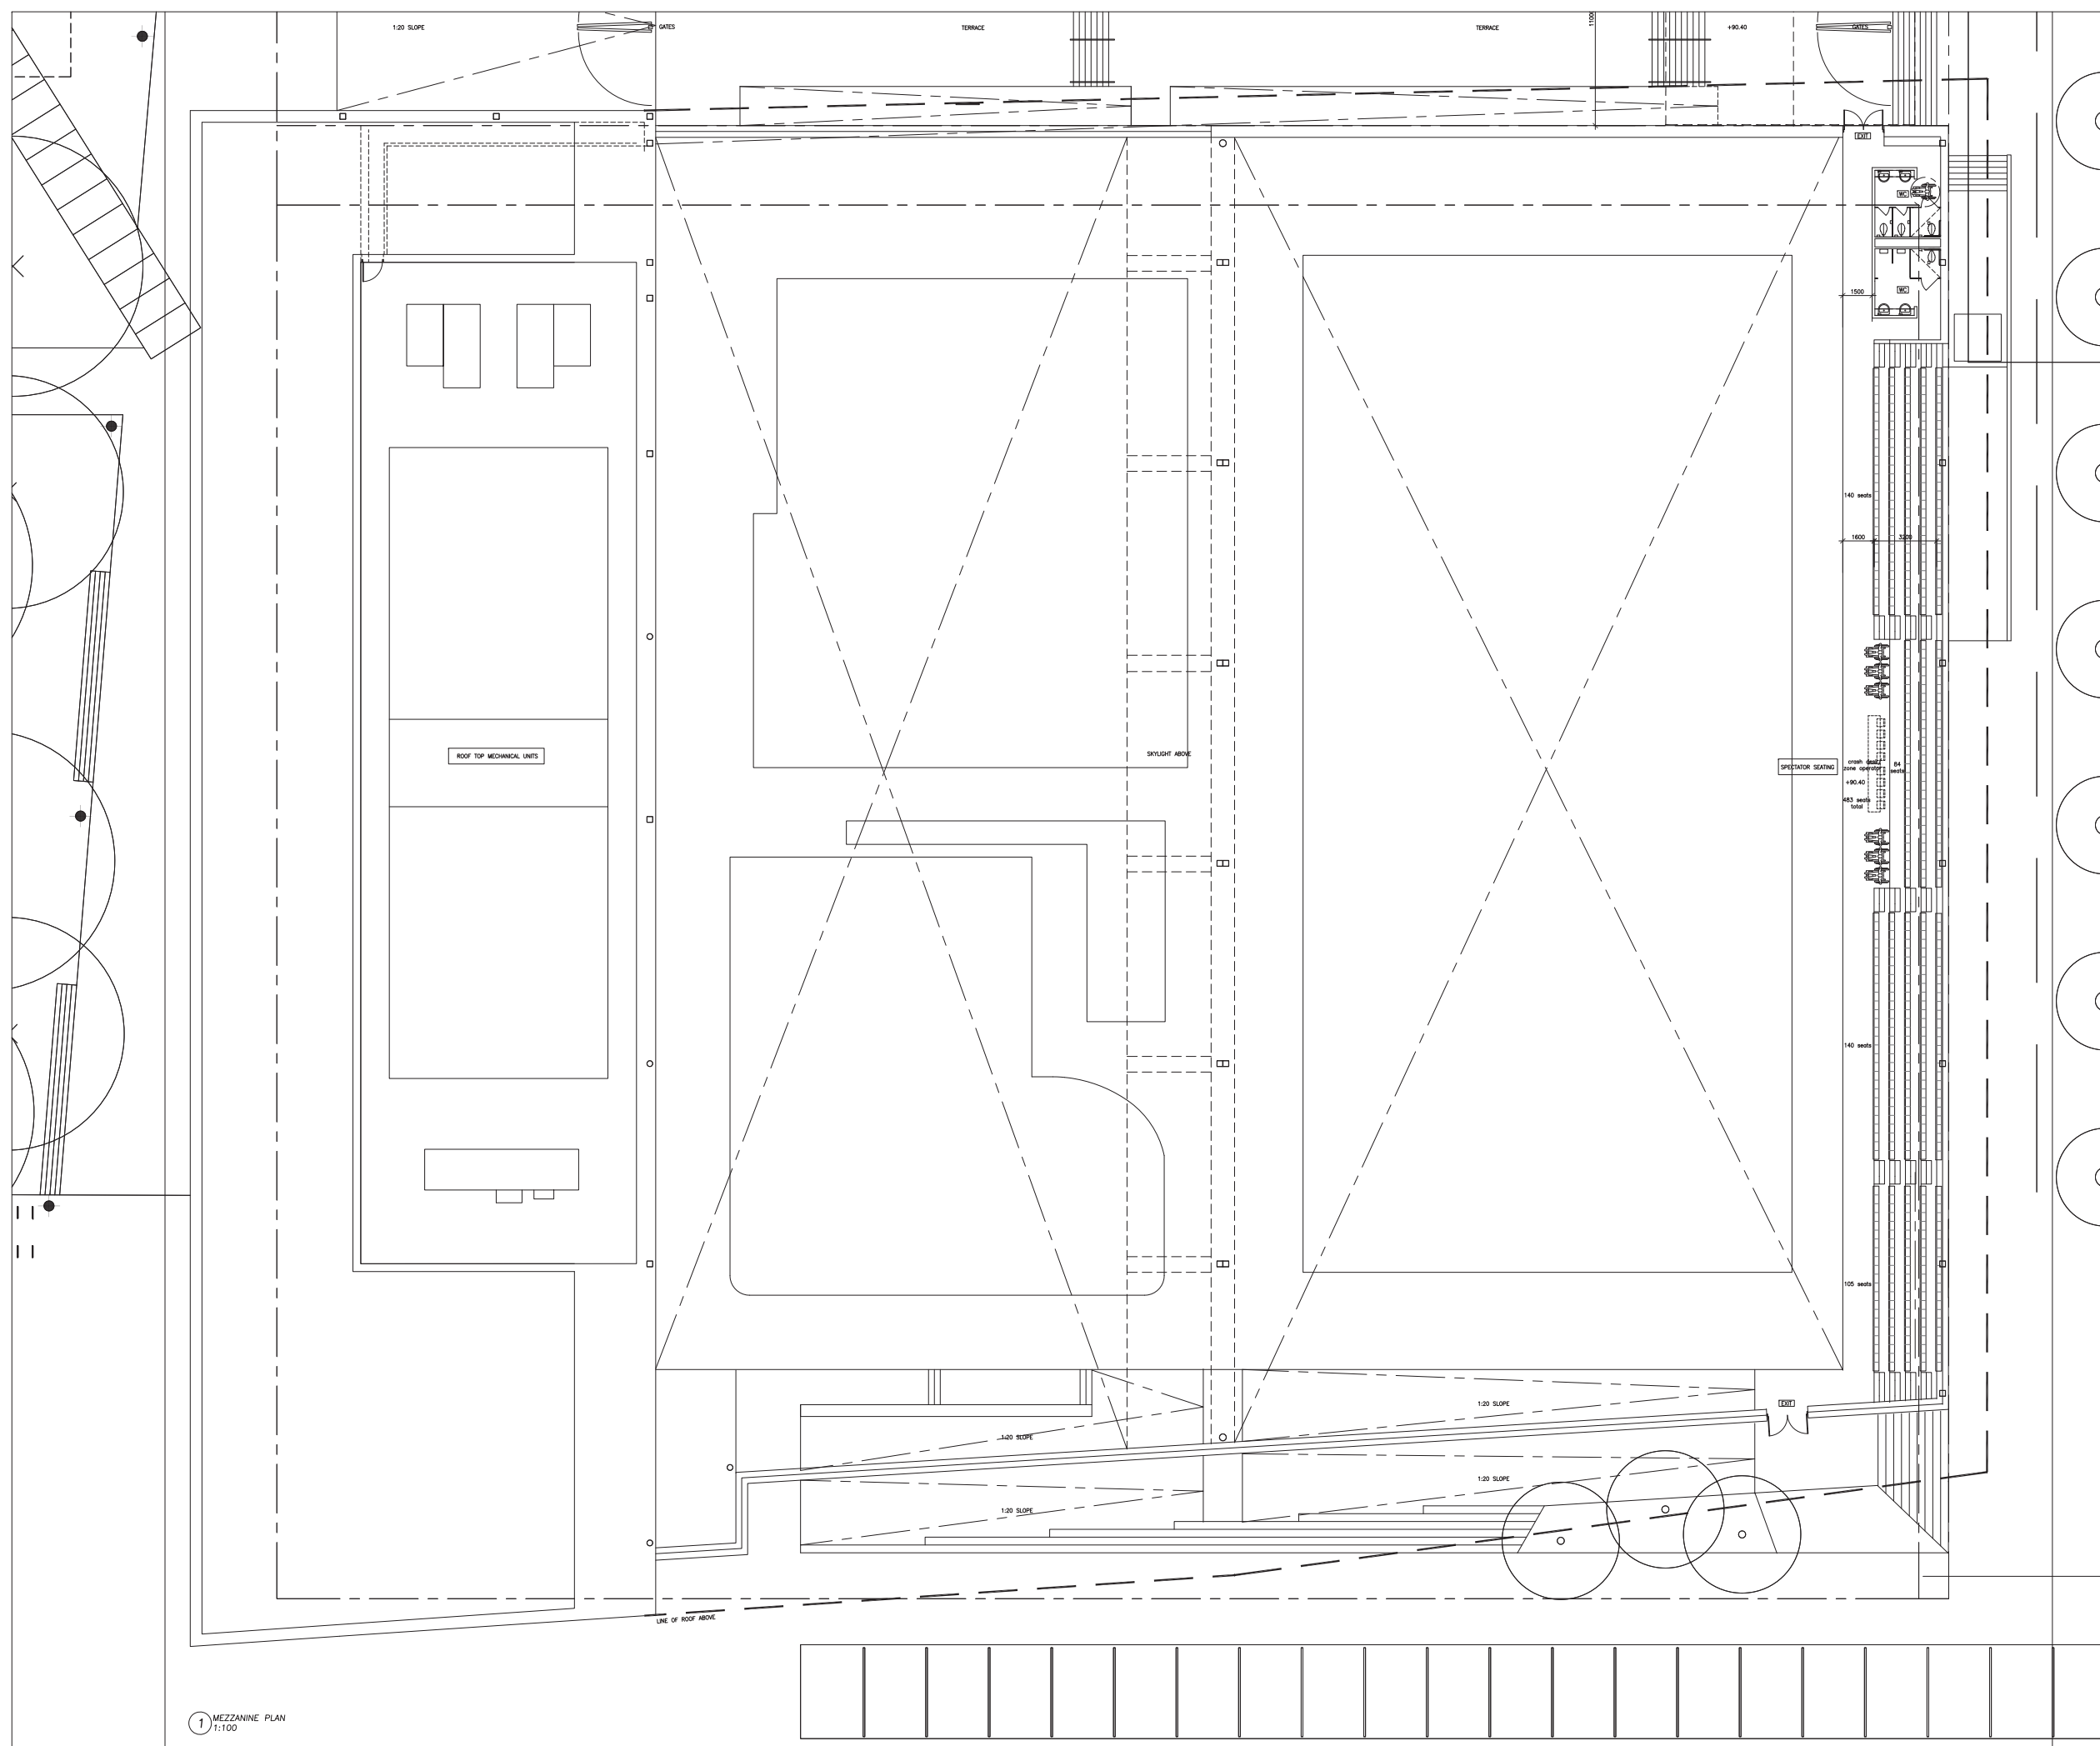

1 MEZZANINE PLAN
1:100

Contractor must check and verify all dimensions on the job, and report any discrepancies to the architect before proceeding with the work. Do not scale this drawing.

| REVISIONS AND ISSUES | DATE | BY |
|---------------------------------|-------------|---------|
| 1 ISSUED FOR DEVELOPMENT PERMIT | APR 10/2013 | AJA/KAM |
| 2 | | |
| 3 | | |
| 4 | | |
| 5 | | |
| 6 | | |
| 7 | | |
| 8 | | |

MJMA + AOA
ARCHITECTS
1025 WEST 4TH AVENUE
VANCOUVER, BC V6H 1V5
TEL: (604) 681-1111 FAX: (604) 681-1112

KAMPS ENGINEERING LTD.
CIVIL ENGINEERS
79 CHESTNUT AVE.
TORONTO, ON M4W 1K7
TEL: (416) 464-8202

PHILLIPS FARCYAAG SMALLENBERG
LANDSCAPE ARCHITECTS
1777 WEST 34th AVE.
VANCOUVER, BC V6K 1K7
TEL: (604) 736-5146 FAX: (604) 736-5147

EQUILIBRIUM
STRUCTURAL ENGINEERS
202-108 W 6th AVENUE
VANCOUVER, BC V6T 3J2
TEL: (604) 681-1422 FAX: (604) 681-8191

AME CONSULTING GROUP
MECHANICAL ENGINEERS
501-134 ARBUTT STREET
VANCOUVER, BC V6B 2K4
TEL: (604) 684-5995 FAX: (604) 684-5995

APPLIED ENGINEERING SOLUTIONS
ELECTRICAL ENGINEERS
400-400 WEST PENDER STREET
VANCOUVER, BC V6C 1L6
TEL: (604) 688-8900 FAX: (604) 688-8911


WTI TECHNOLOGIES
MECHANICAL CONSULTANTS
100 PARK AVENUE
BURNABY, BC V5A 1S4
TEL: (604) 291-7333 FAX: (604) 291-7996

LDMC
CODE CONSULTANTS
4th FLOOR - 780 BENTLEY ST.
VANCOUVER, BC V6P 2M1
TEL: (604) 682-7140 FAX: (604) 682-7149

RECOLLECTIVE
LEED/GREENWASH CONSULTANTS
210-128 WEST HASTINGS STREET
VANCOUVER, BC V6B 1Z8
TEL: (604) 688-8842 FAX: (604) 688-8842

DANIEL LYZUN & ASSOCIATES
MECHANICAL CONSULTANTS
367-901 WEST 3rd STREET
NORTH VANCOUVER, BC V7P 3P9
TEL: (604) 966-6050

UNIVERSITY OF BRITISH COLUMBIA
2205 WEST MALL
VANCOUVER, BC CANADA V6T 1Z4
T: 604.822.2211

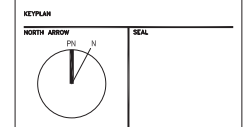


PROJECT TITLE
UBC AQUATIC CENTRE

DRAWING TITLE
MEZZANINE PLAN

SCALE
1:100

DATE
APRIL 2013

PROJECT NUMBER
1208
DRAWING NUMBER
A102

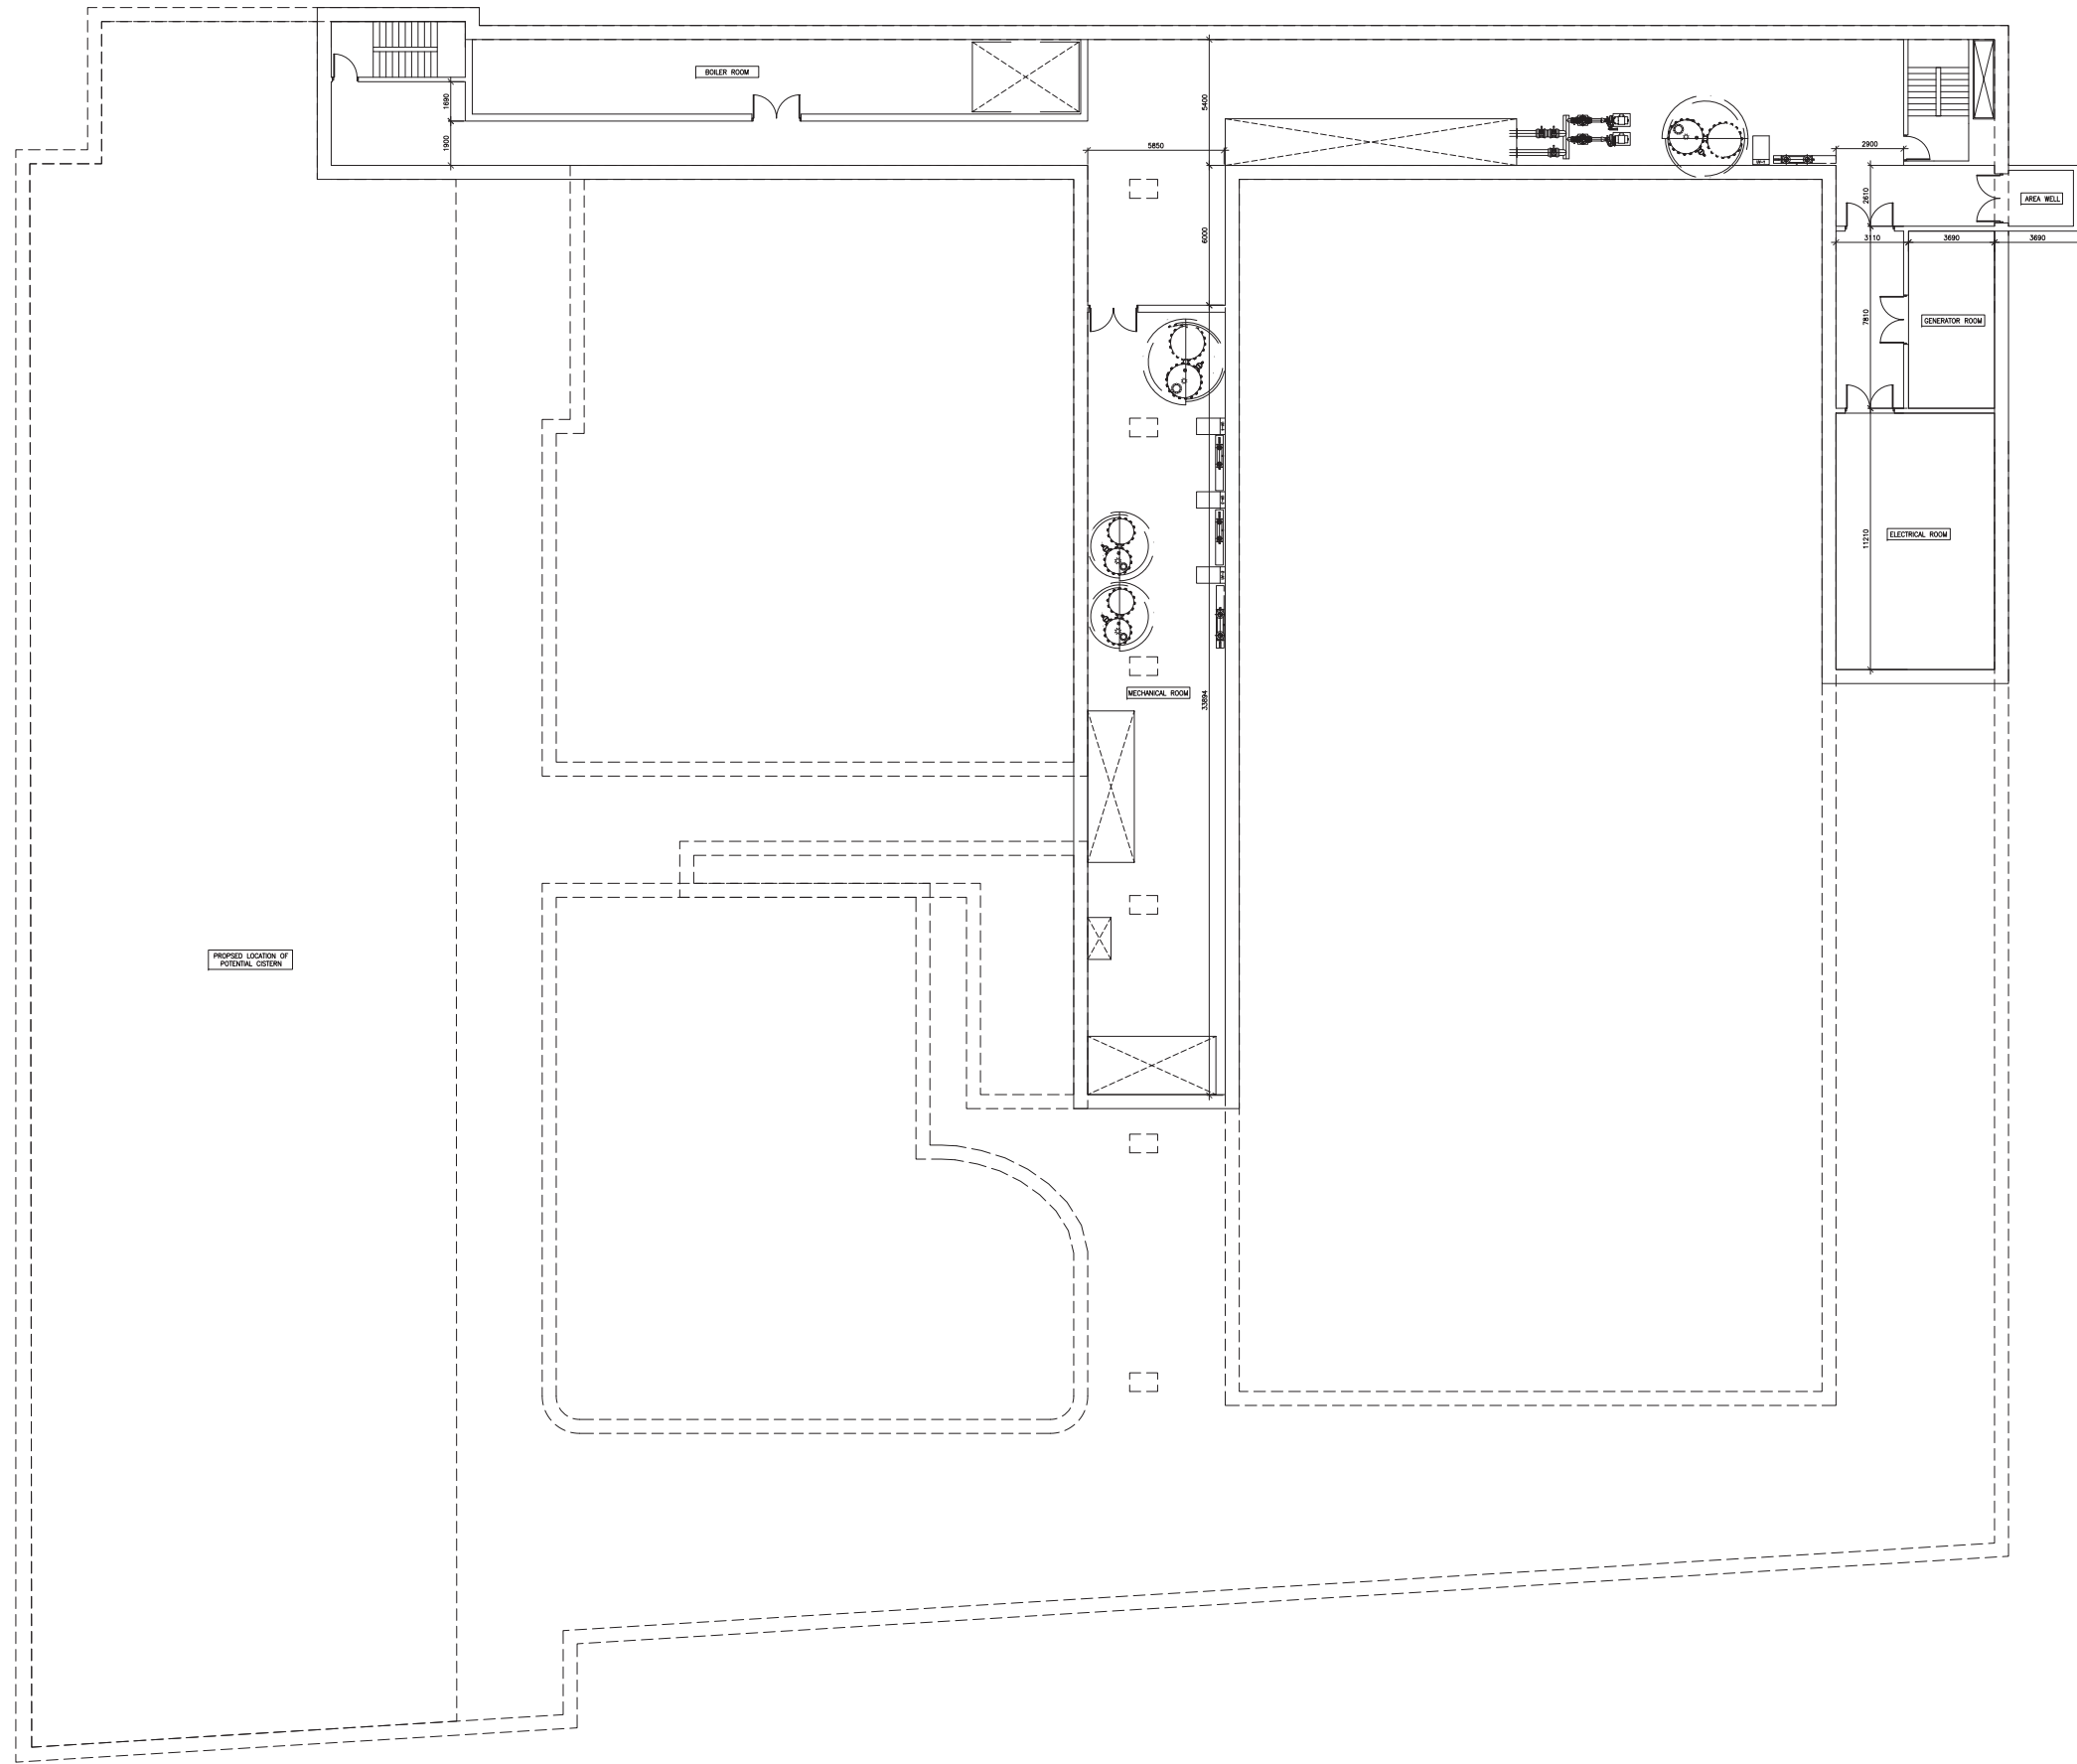

PROPOSED LOCATION OF POTENTIAL CYSTERN

Contractor must check and verify all dimensions on the job, and report any discrepancies to the architect before proceeding with the work. Do not scale this drawing.

| REV | DESCRIPTION | DATE | BY |
|-----|-------------------------------|-------------|---------|
| 1 | ISSUED FOR DEVELOPMENT PERMIT | APR 22/2013 | AJA/ANM |
| 2 | | | |
| 3 | | | |
| 4 | | | |
| 5 | | | |
| 6 | | | |
| 7 | | | |
| 8 | | | |

MJMA + AOA
 ARCHITECTS
 1500 WEST 10TH AVENUE
 VANCOUVER, BC V6H 1T7
 TEL: (604) 681-1111 FAX: (604) 681-1112

KAMPS ENGINEERING LTD.
 CIVIL ENGINEERS
 79 CHESTER AVE.
 TORONTO, ON M4W 1K7
 TEL: (416) 464-6002

PHILLIPS FARCYAAG SMALLENBERG
 LANDSCAPE ARCHITECTS
 1777 WEST 34th AVE.
 VANCOUVER, BC V6K 1K7
 TEL: (604) 736-5146 FAX: (604) 736-5147

EQUILIBRIUM
 STRUCTURAL ENGINEERS
 202-108 W. 6th AVENUE
 VANCOUVER, BC V6P 3J2
 TEL: (604) 681-1422 FAX: (604) 738-8191

AME CONSULTING GROUP
 MECHANICAL ENGINEERS
 501-134 ARBUTT STREET
 VANCOUVER, BC V6B 2K4
 TEL: (604) 684-5995 FAX: (604) 684-5995

APPLIED ENGINEERING SOLUTIONS
 ELECTRICAL ENGINEERS
 606-606 WEST PENDER STREET
 VANCOUVER, BC V6C 1L6
 TEL: (604) 688-8900 FAX: (604) 688-6911


WTI TECHNOLOGIES
 ACOUSTIC CONSULTANTS
 100 PARK AVENUE
 BURNABY, BC V5A 1S6
 TEL: (604) 467-7373 FAX: (604) 467-7395

LDWG
 CODE CONSULTANTS
 4th FLOOR - 760 BENTLEY ST.
 VANCOUVER, BC V6B 2A1
 TEL: (604) 682-7140 FAX: (604) 682-7149

RECOLLECTIVE
 LEED/GREENWELL CONSULTANTS
 210-128 WEST HASTINGS STREET
 VANCOUVER, BC V6B 1S8
 TEL: (604) 683-6942 FAX: (604) 683-6942

DANIEL LYZUN & ASSOCIATES
 ACOUSTIC CONSULTANTS
 367-801 WEST 3rd STREET
 NORTH VANCOUVER, BC V7P 3P9
 TEL: (604) 966-6050

UNIVERSITY OF BRITISH COLUMBIA
 2208 WEST MALL
 VANCOUVER, BC CANADA V6T 1Z4
 T: 604.822.2211

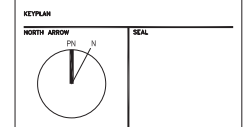

PROJECT TITLE
UBC AQUATIC CENTRE

DRAWING TITLE
BASEMENT PLAN

SCALE
1:100

DATE
APRIL 2013

PROJECT NUMBER
1208
 DRAWING NUMBER
A103

Contractor must check and verify all dimensions on the job, and report any discrepancies to the architect before proceeding with the work.
Do not scale this drawing.

| REV | DESCRIPTION | DATE | BY |
|-----|-------------------------------|-------------|---------|
| 1 | ISSUED FOR DEVELOPMENT PERMIT | APR 10/2013 | AJA/KAM |
| 2 | | | |
| 3 | | | |
| 4 | | | |
| 5 | | | |
| 6 | | | |
| 7 | | | |
| 8 | | | |

MJMA + AOA

1000-1000 STREET, SUITE 100
VANCOUVER, BC V6E 4R1
TEL: (604) 681-1111 FAX: (604) 681-1112

KAMPS ENGINEERING LTD.

79 CHESTNUT AVE.
TORONTO, ON M4W 1E7
TEL: (416) 464-8202

PHILLIPS FARCYAAG SMALLENBERG

1777 WEST 34th AVE.
VANCOUVER, BC V6L 1K7
TEL: (604) 738-5148 FAX: (604) 738-5147

EQUILIBRIUM

STRUCTURAL ENGINEERS
202-108 W 6th AVENUE
VANCOUVER, BC V6P 3J2
TEL: (604) 681-1422 FAX: (604) 738-8191

AME CONSULTING GROUP

MEDICAL ENGINEERS
501-134 ARBUTT STREET
VANCOUVER, BC V6B 2A4
TEL: (604) 684-5985 FAX: (604) 684-5985

APPLIED ENGINEERING SOLUTIONS

ELECTRICAL ENGINEERS
400-608 WEST PENDER STREET
VANCOUVER, BC V6C 1L8
TEL: (604) 688-8900 FAX: (604) 688-8911

WTI TECHNOLOGIES

ACOUSTIC CONSULTANTS
100 PARK AVENUE
REXDALE, ON L4R 1S4
TEL: (905) 887-7995 FAX: (905) 887-7995

LDWG

CODE CONSULTANTS
4th FLOOR - 760 BENTLEY ST.
VANCOUVER, BC V6B 2A1
TEL: (604) 682-7140 FAX: (604) 682-7140

RECOLLECTIVE

LEED/POSTOCCUPANCY CONSULTANTS
210-128 WEST HASTINGS STREET
VANCOUVER, BC V6B 1G8
TEL: (604) 688-8845 FAX: (604) 688-8845

 
DANIEL LYZUN & ASSOCIATES

ACOUSTIC CONSULTANTS
267-901 WEST 3rd STREET
NORTH VANCOUVER, BC V7P 3P9
TEL: (604) 966-6050

UNIVERSITY OF BRITISH COLUMBIA

2208 WEST MALL
VANCOUVER, BC CANADA V6T 1Z4
T: 604.822.2211

KEY PLAN




PROJECT TITLE
UBC AQUATIC CENTRE

DRAWING TITLE
ROOF PLAN

SCALE
1:100

DATE
APRIL 2013

PROJECT NUMBER
1208
DRAWING NUMBER
A104

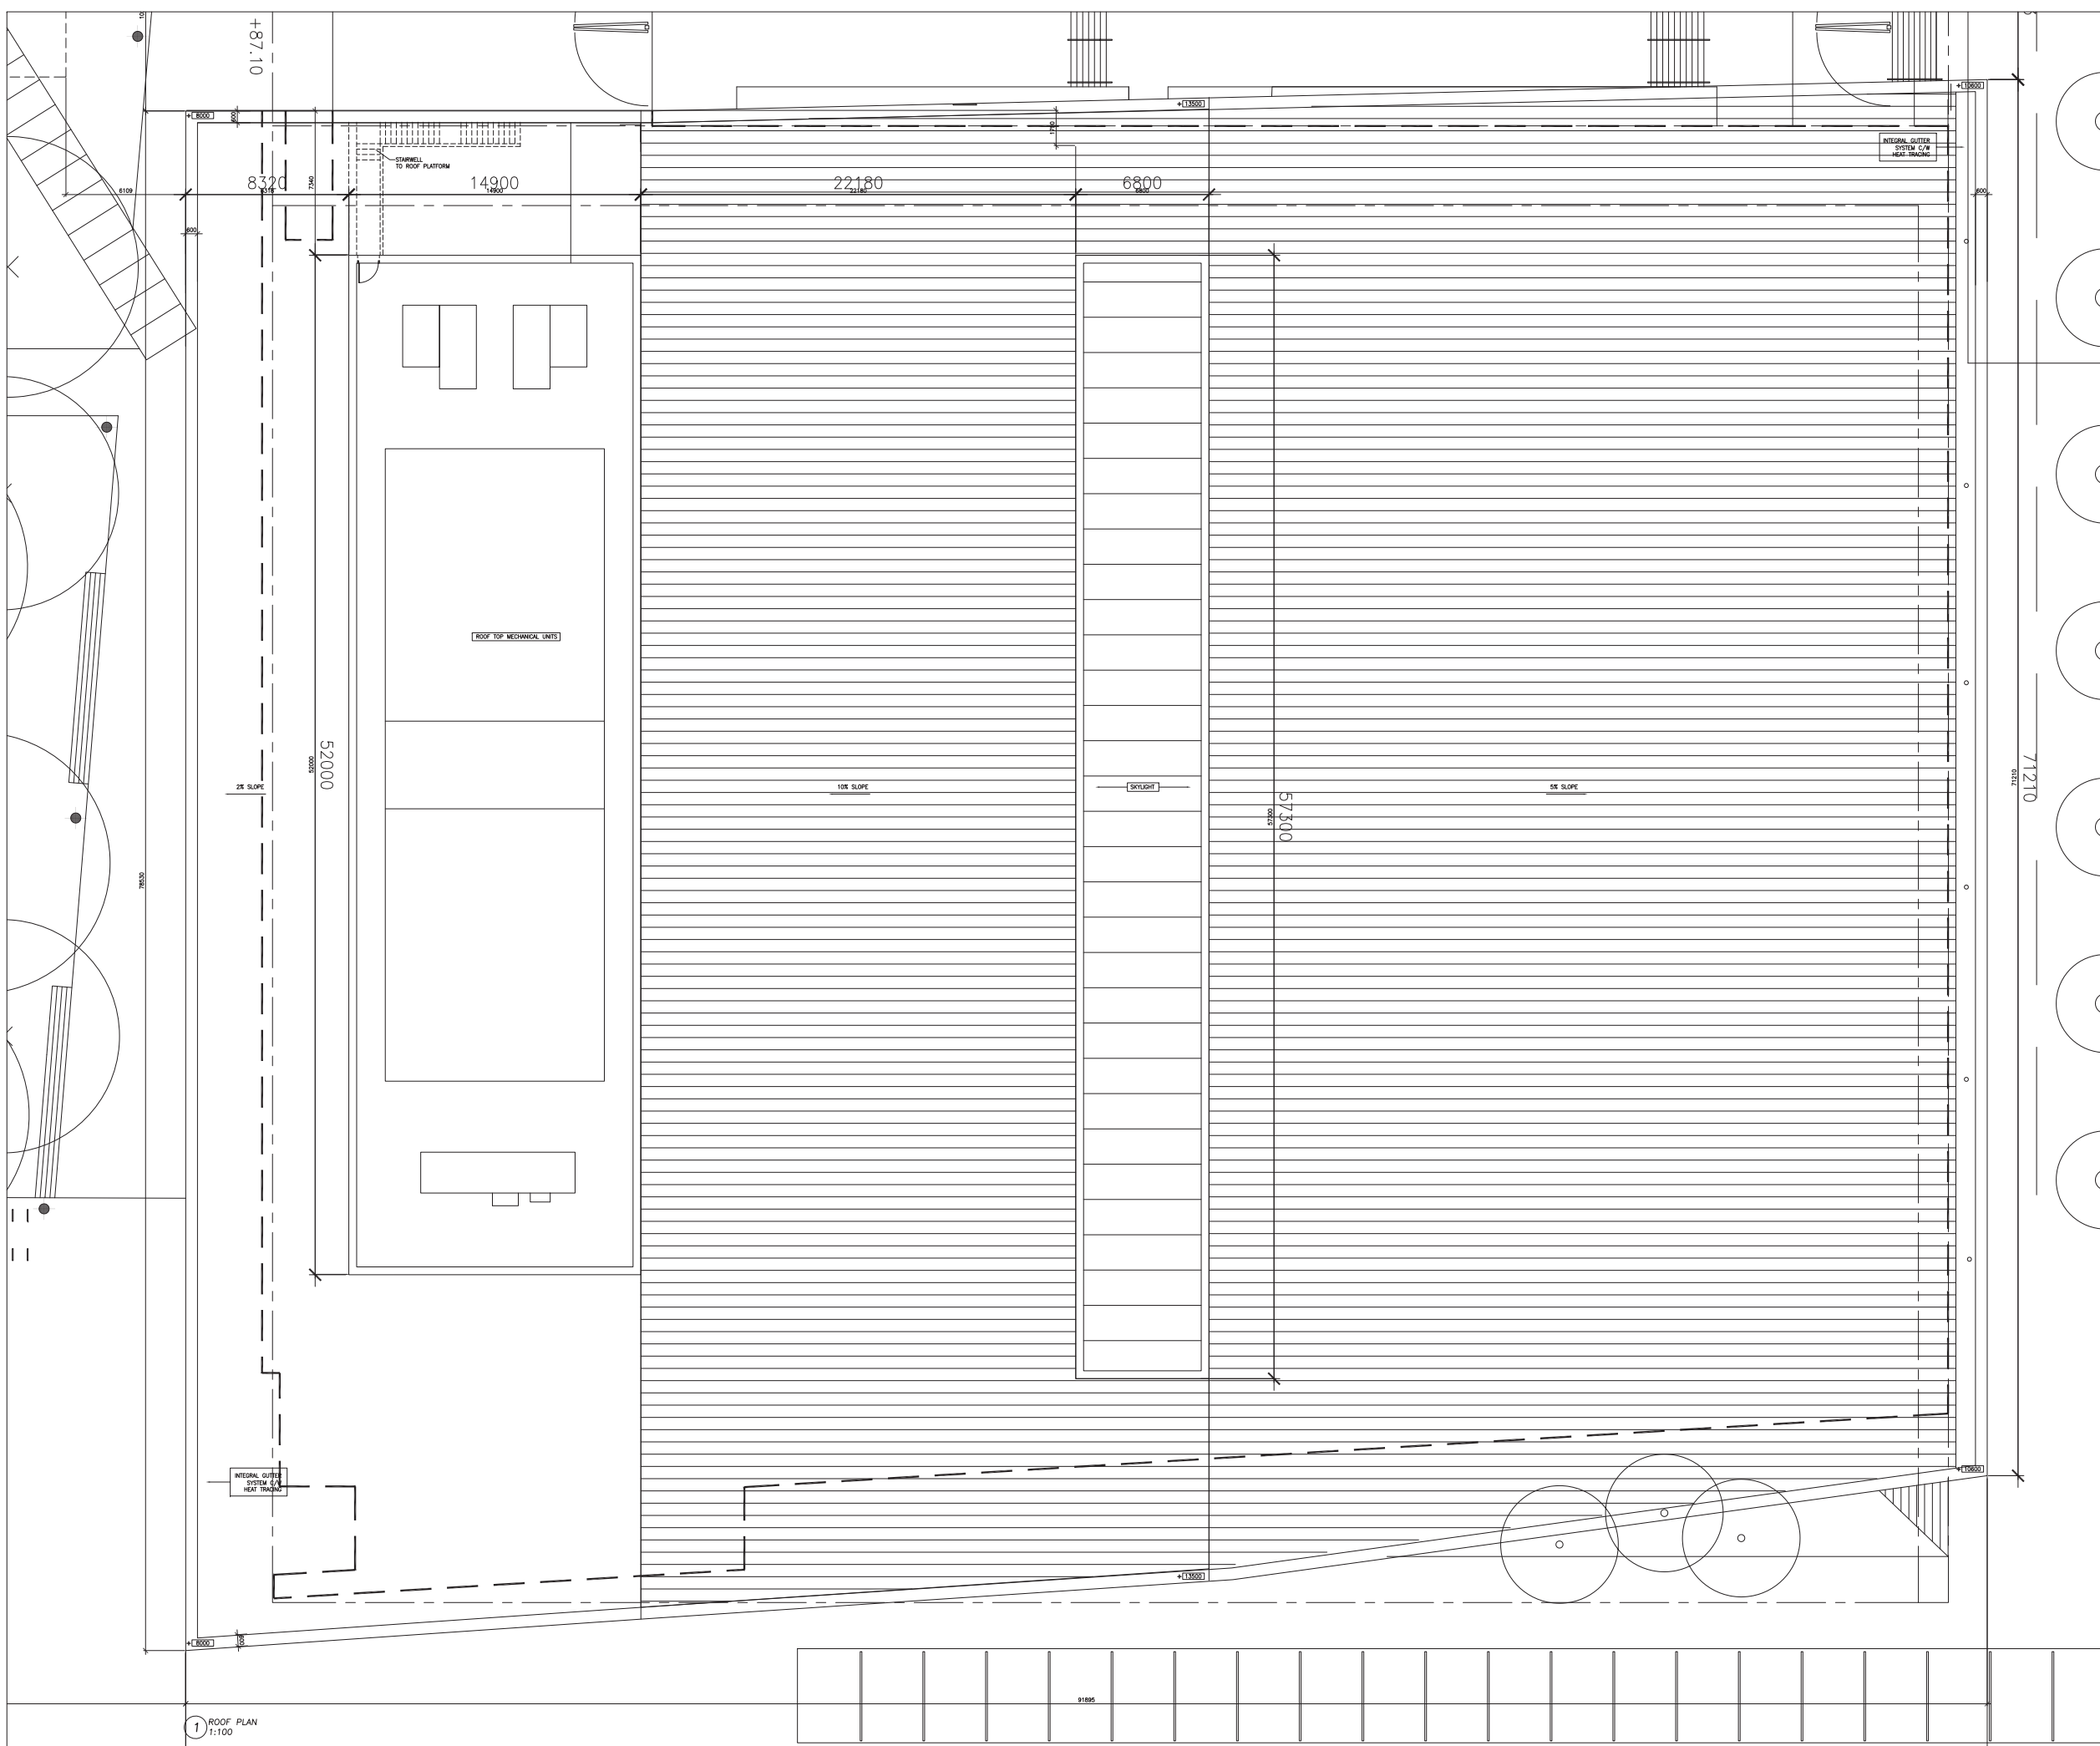

1 ROOF PLAN
1:100

91885